




DESIGNED BY: VHR	DATE: 05-2019
DRAWN BY: NCF	PROJ. NO.: 2018-0-808
CHECKED BY: PW	
APPROVED BY: OES	

FACILITY DRAINAGE PLAN

BEE CANYON GREENERY

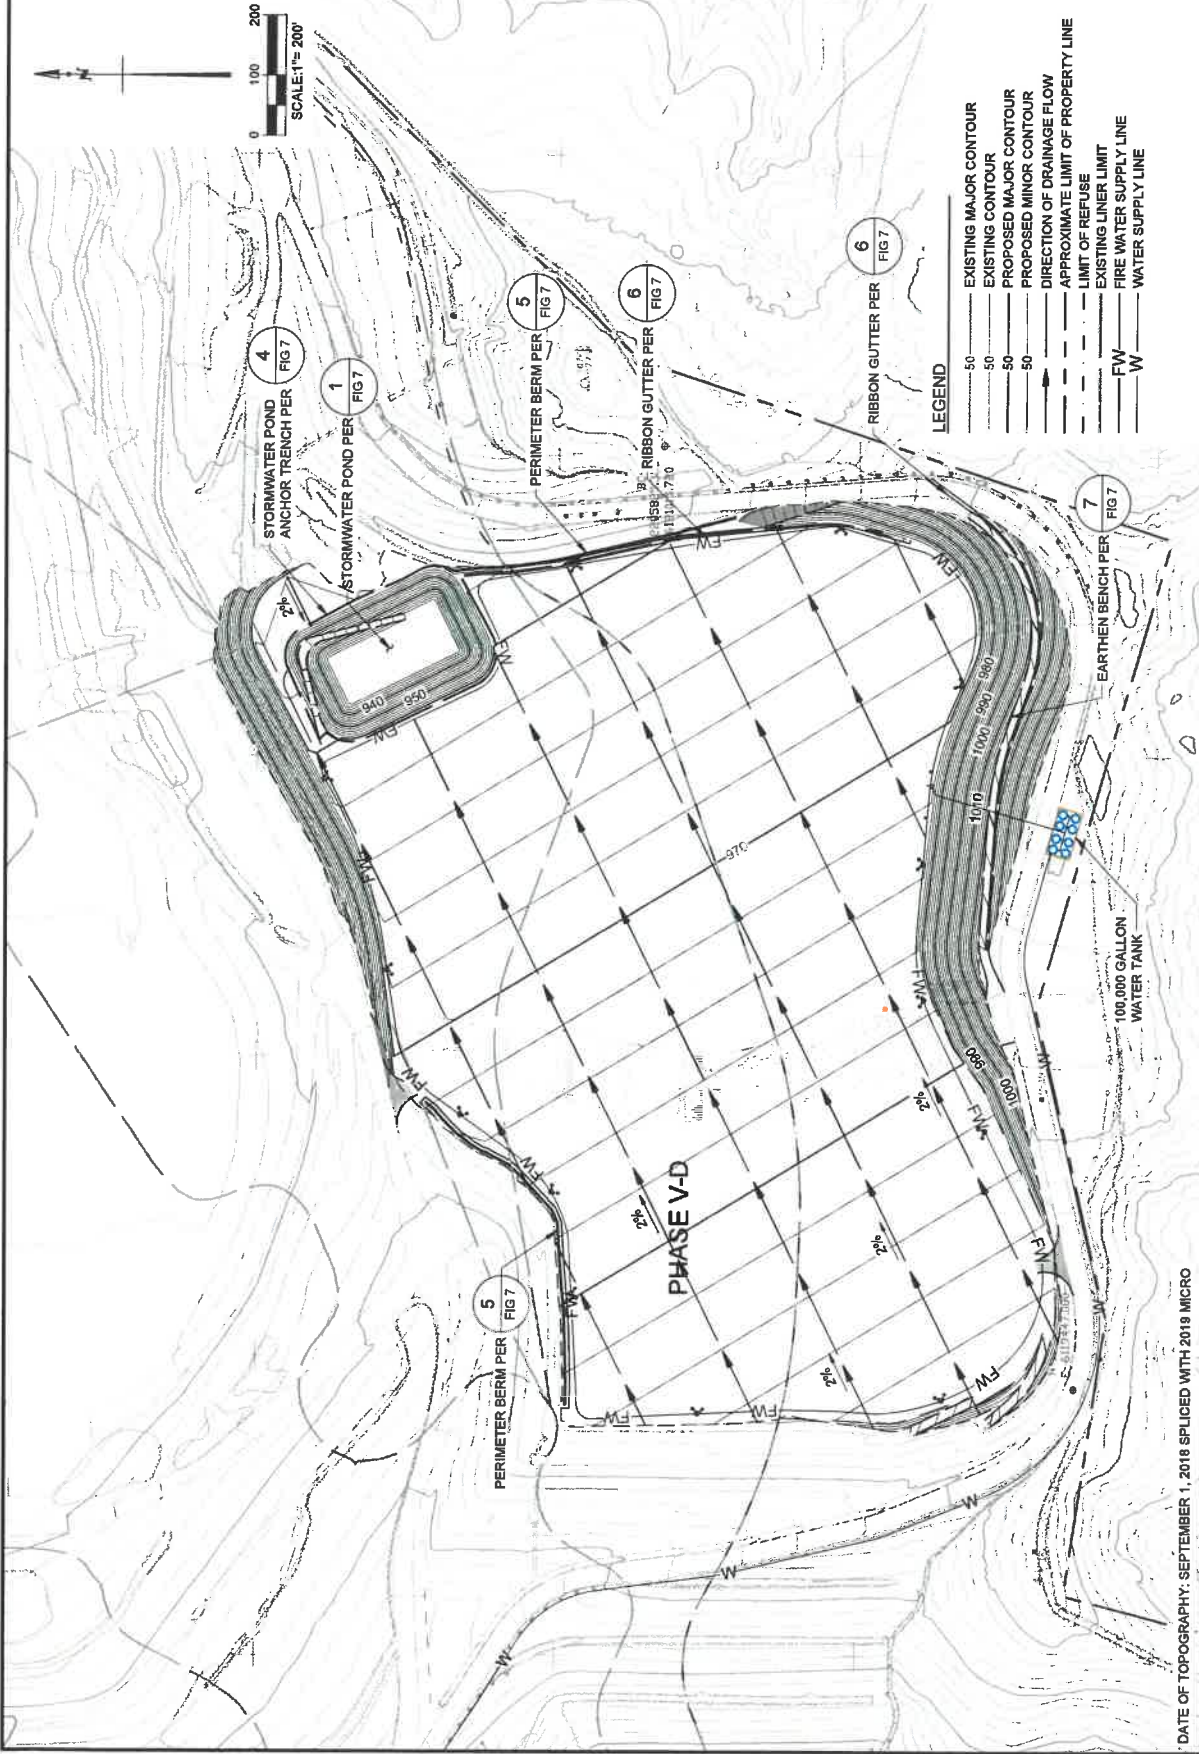

DATE OF TOPOGRAPHY: SEPTEMBER 1, 2018 SPLICED WITH 2019 MICRO

P:\OCM\FR\Bee Canyon Greenery\Drawings\Phase V-D\Facility Drainage Plan