



PRELIMINARY PROPOSED PLANT PALETTE



BOTANICAL NAME	COMMON NAME	SIZE	WIDTH / HEIGHT	WATER USE	QUANTITY
TREES					
#XX EXISTING TREE TO REMAIN #XXX					
#XX EXISTING TREE TO BE REMOVED #XXX					
SPECIMEN TREES					
OLEA 'WILSONII'	WILSON OLIVE	24" BOX	25' WIDE/25' HIGH	LOW	3
TRISTANIA CONFERTA	BRISBANE BOX	24" BOX	25' WIDE/30'-40' HIGH	LOW-MEDIUM	5
ACCENT TREES					
PYRUS C. 'CAPITAL'	CAPITAL PEAR	24" BOX	12' WIDE/25' HIGH	LOW	7
EVERGREEN TREES					
ARBUTUS MARINA	STRAWBERRY TREE	24" BOX	20' WIDE/30' HIGH	LOW	6
PRUNUS CAROLINIANA 'COMPACTA'	CAROLINA CHERRY	15 GALLON	15' WIDE/10' HIGH	LOW	13
LAURUS NOBILIS	SWEET BAY	24" BOX	15' WIDE/15' HIGH	LOW	10
BOARDWALK TREES					
ARBUTUS MENZIESII	MADRONE	15 GALLON	30' WIDE/30' HIGH	LOW	1
CORNUS NUTTALLII	PACIFIC DOGWOOD	15 GALLON	15' WIDE/15' HIGH	LOW	10
SHRUBS					
ACH 'MOO'	ACHILLEA X 'MOONSHINE'	MOONSHINE YARROW	1 GALLON	LOW	58
ANI 'B.P.'	ANIGOSANTHOS 'BUSH PEARL'	DWARF KANGAROO PAW	1 GALLON	LOW	238
BOU 'B.A.'	BOUTALOUA G. 'BLONDE AMBITION'	BLUE GRAMA GRASS	1 GALLON	LOW	144
BUD 'DW'	BUDDLEIA D. 'DWARF VARIETY'	DWARF BUTTERFLY BUSH	5 GALLON	LOW	24
CHO 'TEC'	CHORONOPETALUM TECTORUM	CAPE RUSH	5 GALLON	LOW	38
CIS 'PRO'	CISTUS S. 'PROSTRATUS'	SAGELEAF ROCKROSE	1 GALLON	LOW	231
DIE 'BIC'	DIETES BICOLOR	FORTNIGHT LILY	1 GALLON	LOW	104
FRA 'CAL'	FRANGULA CALIFORNICA	CALIFORNIA COFFEEBERRY	5 GALLON	LOW	2
GAU 'LIN'	GAURA LINDHEIMERI	LINDHEIMER'S BEEBLOSSOM	1 GALLON	LOW	88
HES 'PAR'	HESPERALOE PARVIFLORA	RED YUCCA	5 GALLON	LOW	73
HES 'PER'	HESPERALOE P. 'PERPA'	BRACKETLIGHTS RED YUCCA	1 GALLON	LOW	219
KNI 'P.P.'	KNIPHOFIA 'PINEAPPLE POPSICLE'	RED HOT POKER	1 GALLON	LOW	213
LAV 'MAR'	LAVATERA MARITIMA	TREE MALLOW	5 GALLON	LOW	99
LOR 'BRE'	LOMANDRA L. 'BREEZE'	DWARF MAT RUSH	1 GALLON	LOW	214
LOR 'E.S.'	LOROPETALUM EMERALD SNOW'	CHINESE FRINGE FLOWER	5 GALLON	LOW	94
MOR 'CAL'	MORELLA CALIFORNICA	CALIFORNIA WAX MYRTLE	1 GALLON	LOW	20
MUH 'RIG'	MUHLENBERGIA RIGENS	DEER GRASS	5 GALLON	LOW	13
OLE 'L.O.'	OLEA E. 'LITTLE OLLIE'	DWARF OLIVE	5 GALLON	LOW	186
PHO 'M.M.'	PHORMIUM T. 'MAORI MAIDEN'	NEW ZEALAND FLAX	5 GALLON	LOW	9
POL 'MUN'	POLYSTICHUM MUNITUM	WESTERN SWORD FERN	1 GALLON	LOW	18
PRU 'BAT'	PRUNUS BRIGHT & TIGHT	BRIGHT & TIGHT LAUREL	5 GALLON	LOW	78
TEU 'CHA'	TEUCHORIUM CHAMAEDRY'S	GERMANDER	1 GALLON	LOW	116
XYL 'COM'	XYLOSMA C. 'COMPACTA'	COMPACT XYLOSMA	5 GALLON	LOW	72
VINES					
LON 'HIS'	LONICERA HISPIDULA	HAIRY HONEYSUCKLE	5 GALLON	LOW	6
SHRUBS - BIO-RETENTION					
BUD 'DW'	BUDDLEIA 'DWARF VARIETIES'	DWARF BUTTERFLY BUSH	1 GALLON	LOW	15
CAR 'DIP'	CAREX DIPSAKIA	AUTUMN SEDGE	1 GALLON	LOW	175
JUN 'PAT'	JUNCUS PATENS	CALIFORNIA RUSH	1 GALLON	LOW	210

SUMMARY DATA TABLE:


LANDSCAPE AREA	QUANTITY	%
TOTAL SITE AREA	99,150	100%
TOTAL LANDSCAPED AREA	18,466	18.6%
AREA OF 15' SETBACK AT MERRYDALE RD.	3,848	100%
LANDSCAPED AREA WITHIN SETBACK	2,093	55%
PROPOSED PLANTING		
TOTAL TREES	55	100%
24" BOX TREES	31	56%
15 GALLON TREES	24	44%
TOTAL SHRUBS	2,651	100%
5 GALLON	1,180	60%
1 GALLON	1,771	40%
PROPOSED AMENITIES		
POLE LIGHTS	9	
LIGHT BOLLARDS	58	

NOTES:

- ALL TREES SHALL BE PLANTED AND STAKED PER CITY STANDARDS.
- TREES BE PLANTED WITHIN 3' OF HARDSCAPE ELEMENTS, SHALL HAVE A LINEAR ROOT BARRIER INSTALLED ADJACENT TO THE HARDSCAPE ELEMENT AT TIME OF TREE PLANTING.
- LANDSCAPE AND IRRIGATION SHALL COMPLY WITH CITY'S CURRENT WATER-EFFICIENT LANDSCAPE ORDINANCE.
- ALL PLANTING AREAS SHALL BE AUTOMATICALLY IRRIGATED PER CITY STANDARDS. USING LOW-FLOW SPRAY, BUBBLERS OR DRIP METHODS.
- ALL PLANTING AREAS SHALL BE MULCHED TO A MINIMUM DEPTH OF 3".

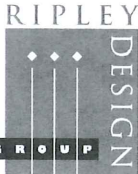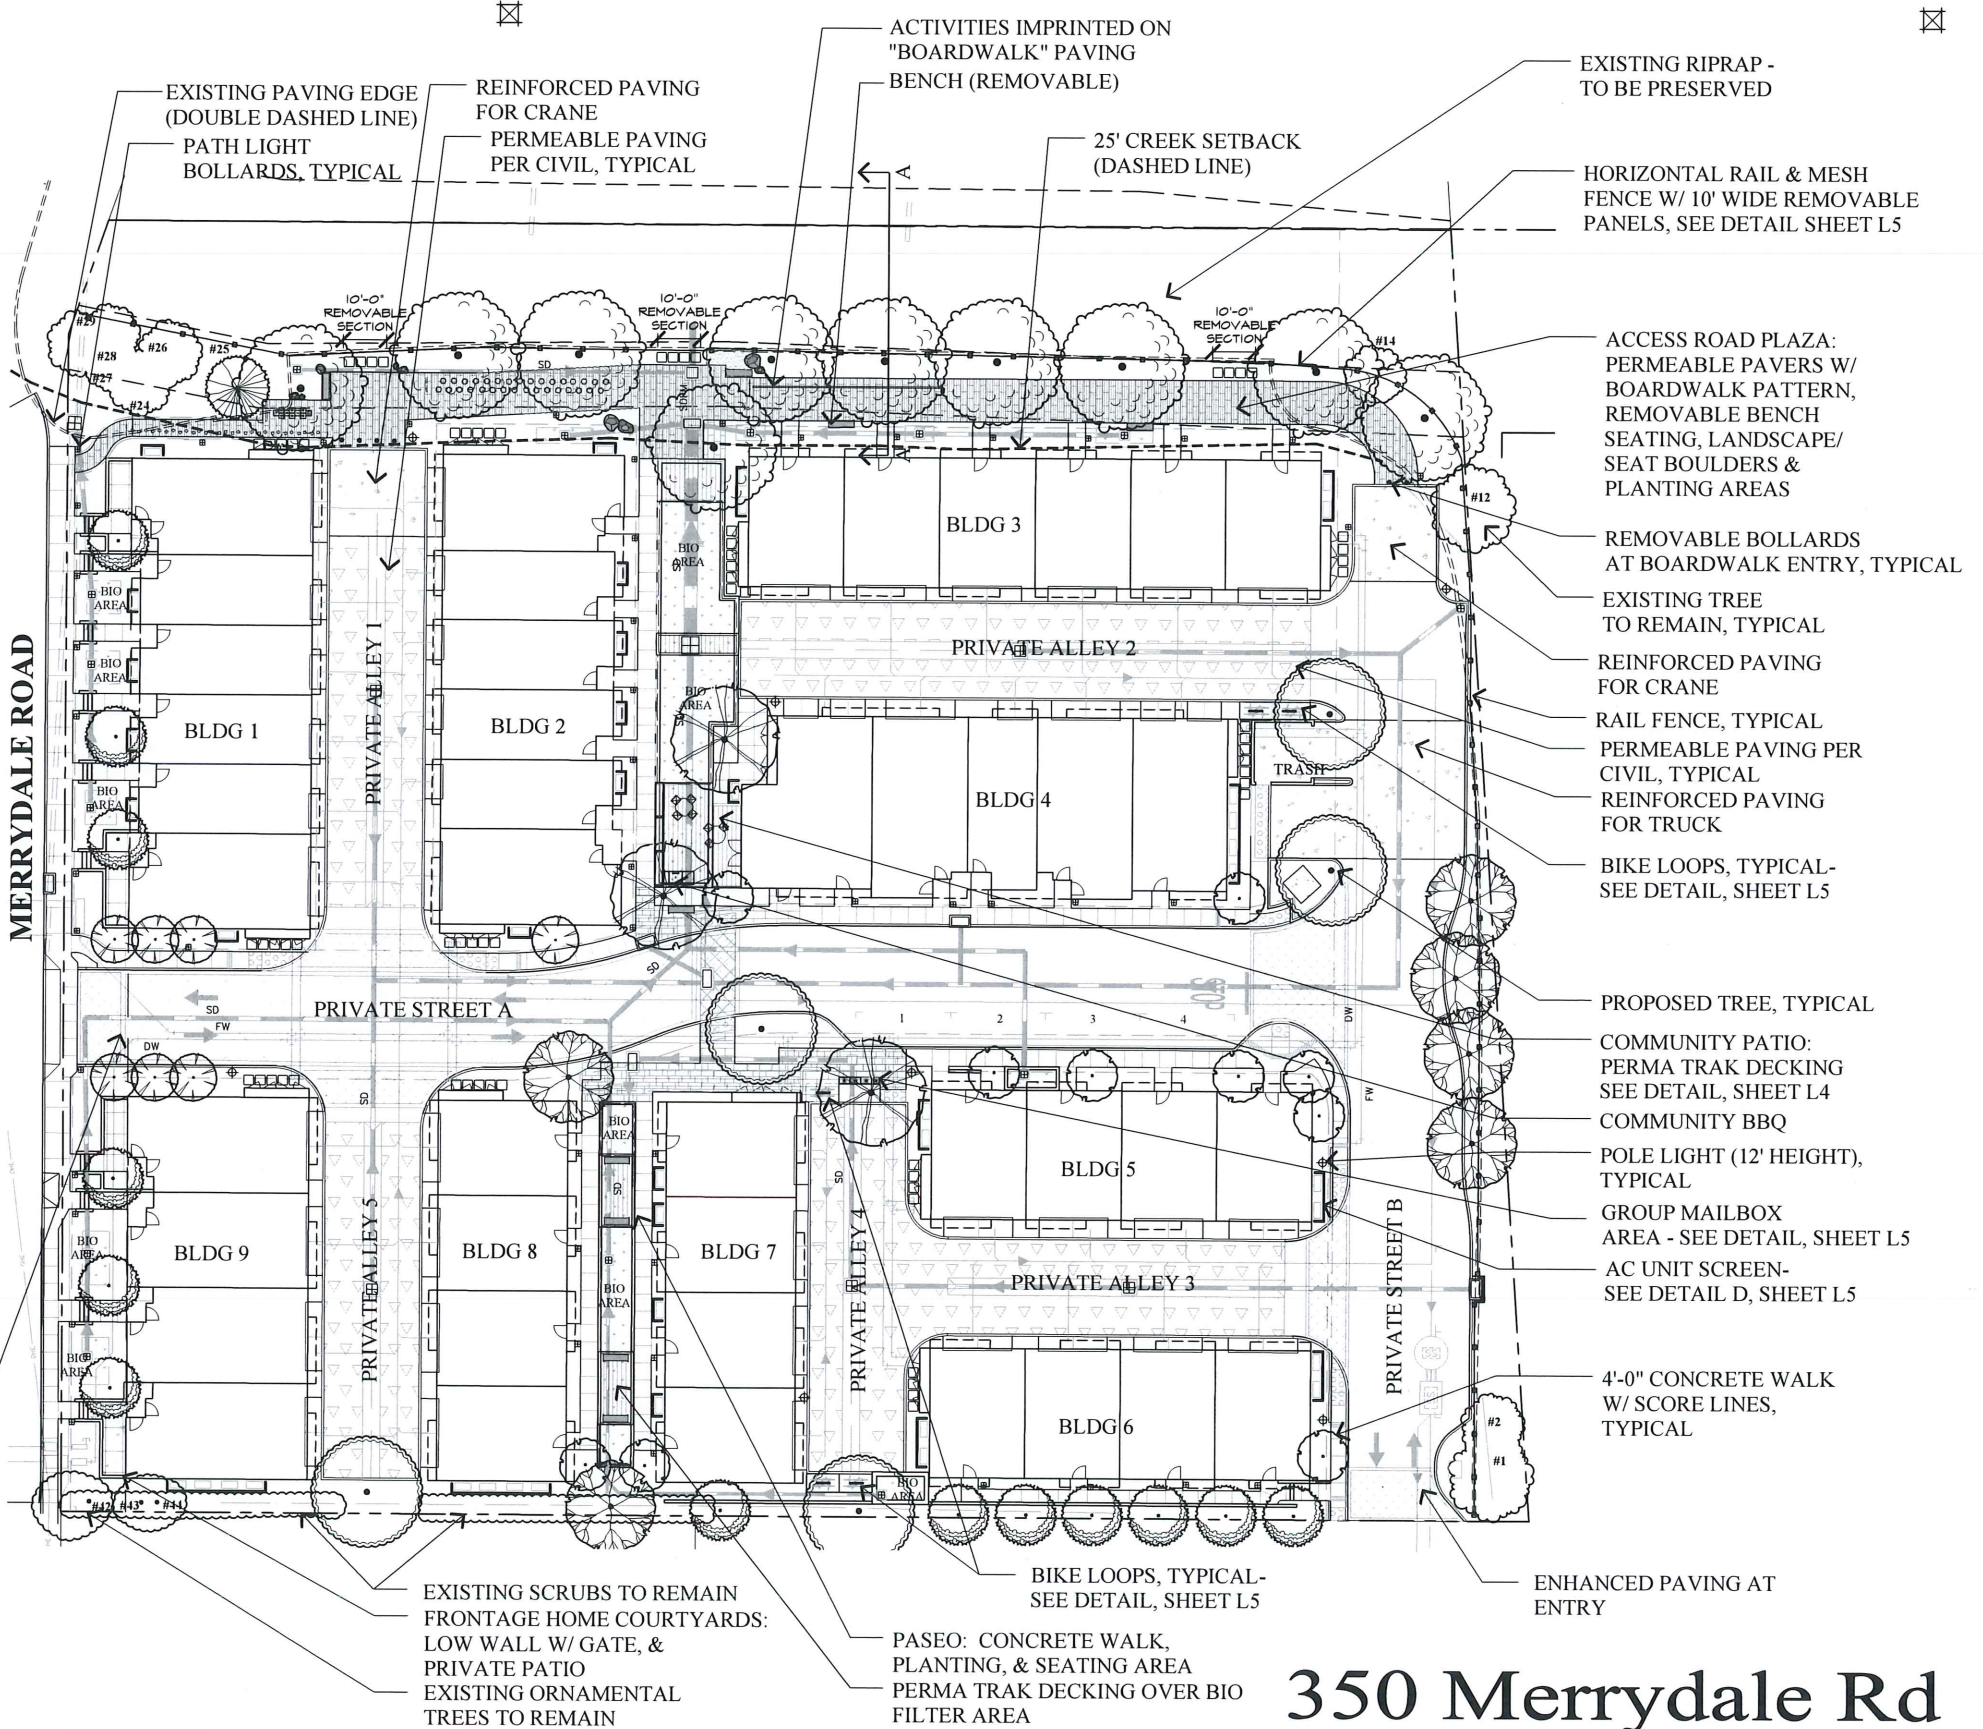

LANDSCAPE ARCHITECTURE
LAND PLANNING
1615 BONANZA STREET
SUITE 314
WALNUT CREEK, CA 94596
TEL: 925.938.7377
FAX: 925.938.7436

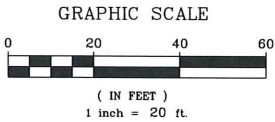


CAMPUS PROPERTY GROUP

Landscape & Lighting Plan

350 Merrydale Rd


San Rafael, California

OCTOBER, 2019

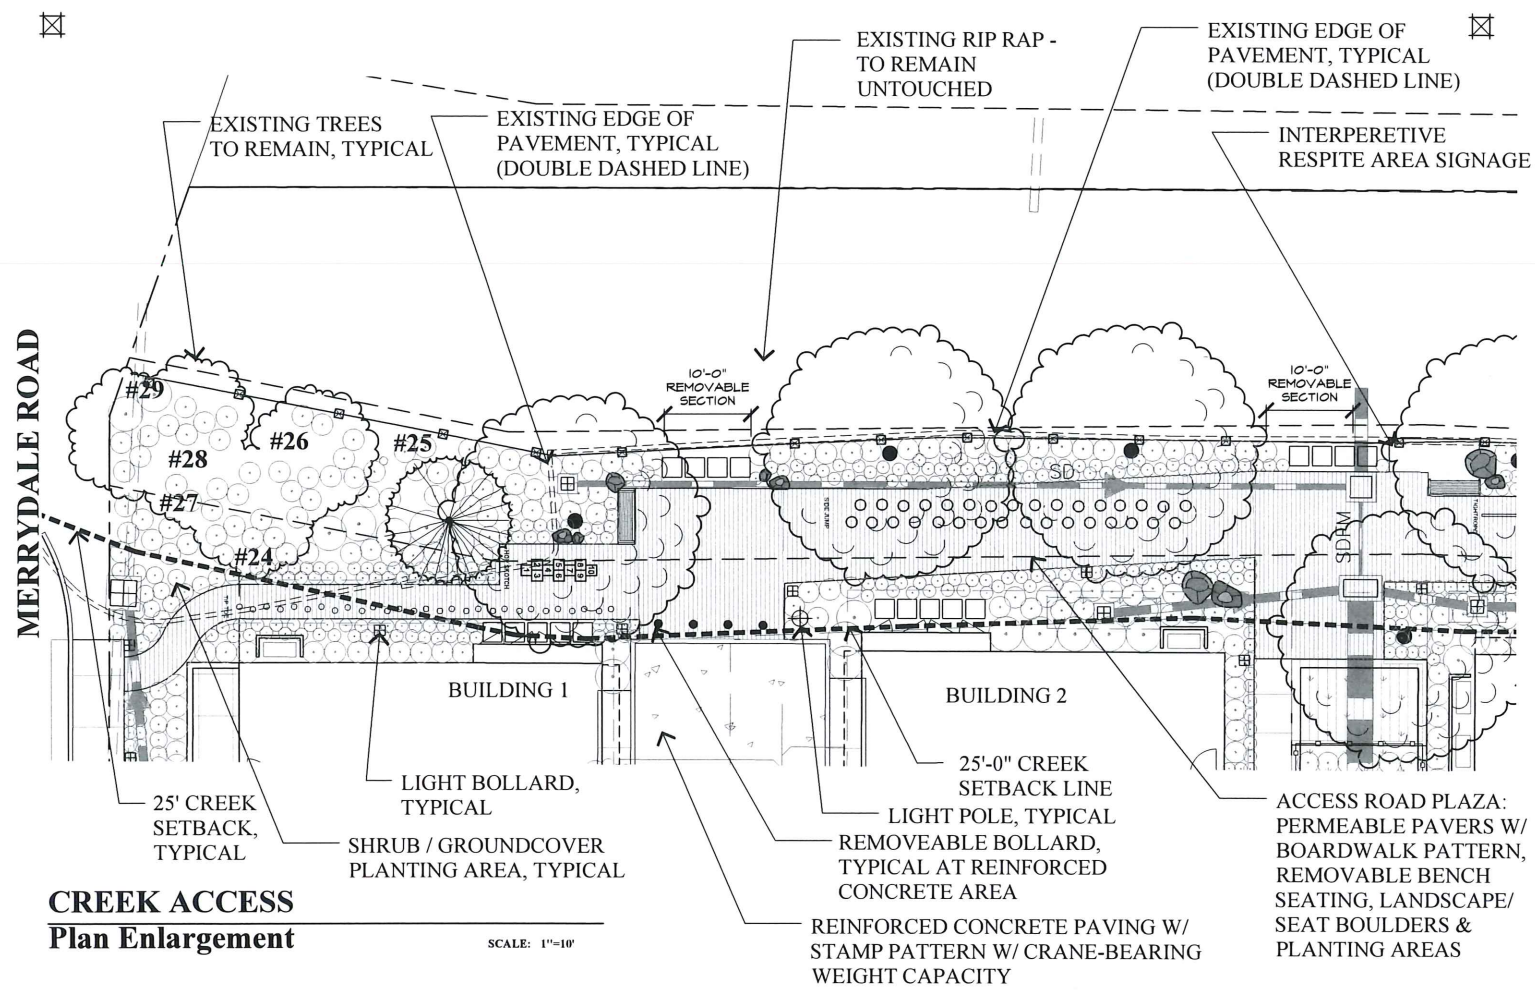


CREEK ACCESS
Plan Enlargement

SCALE: 1"=10'

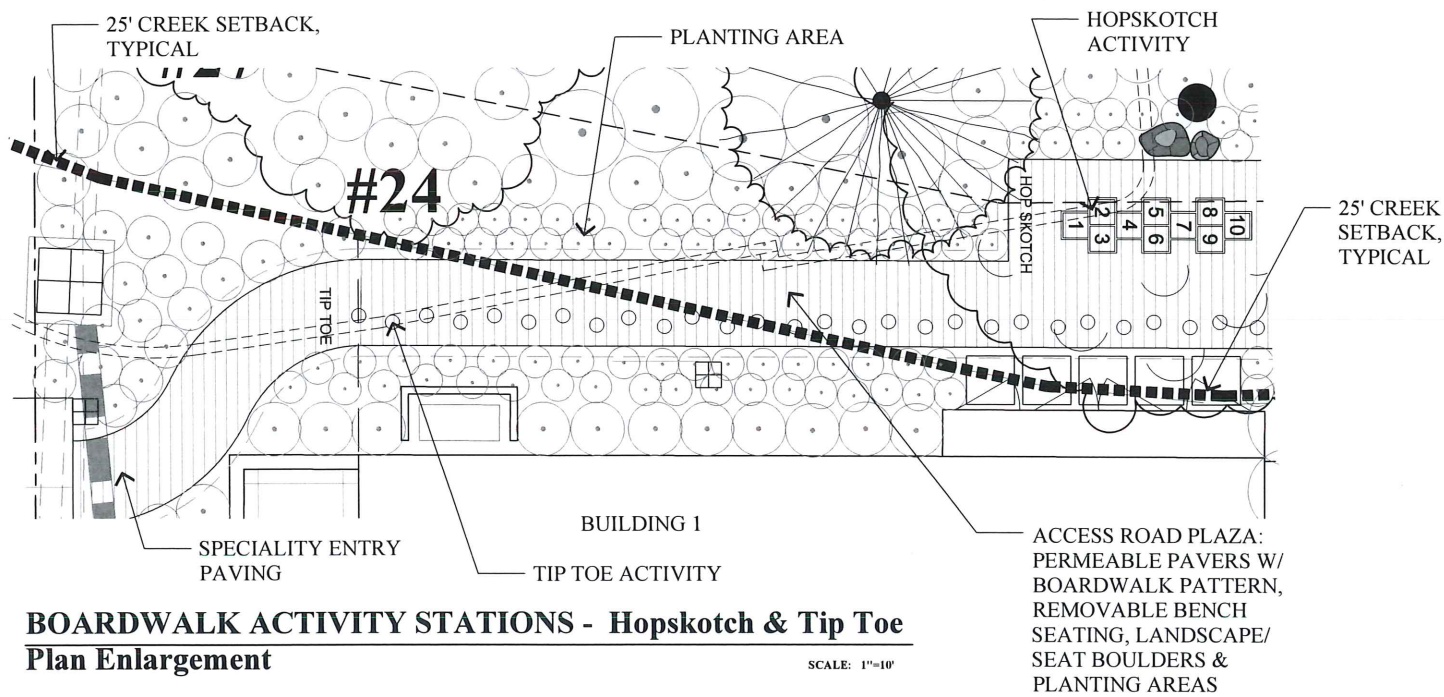


BOARDWALK ACTIVITY STATIONS - Hopskotch & Tip Toe
Plan Enlargement

SCALE: 1"=10'

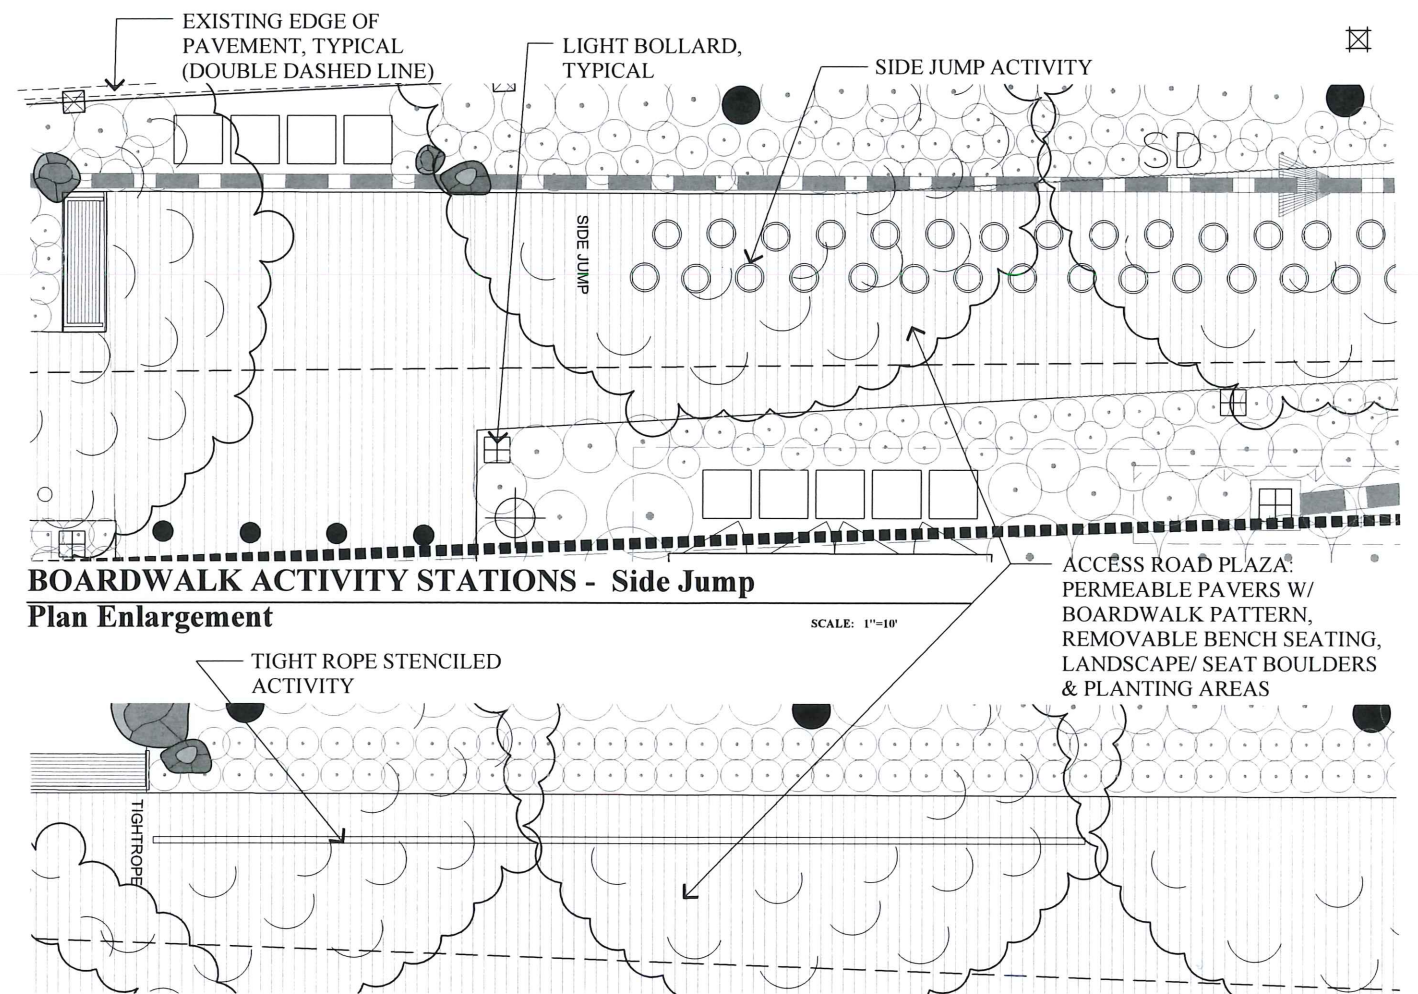

BOARDWALK ACTIVITY STATIONS - Side Jump
Plan Enlargement

SCALE: 1"=10'

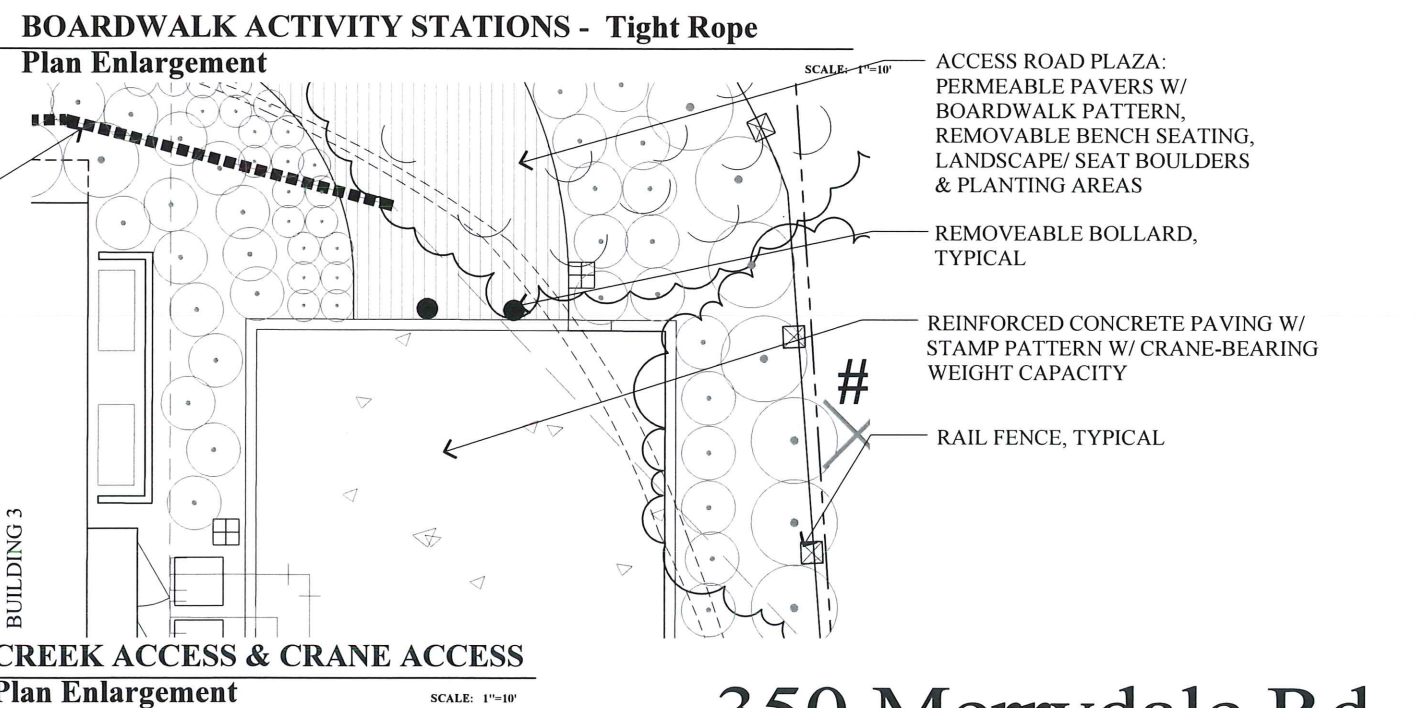

CREEK ACCESS & CRANE ACCESS
Plan Enlargement

SCALE: 1"=10'

350 Merrydale Rd



LANDSCAPE ARCHITECTURE
LAND PLANNING
1615 BONANZA STREET
SUITE 314
WALNUT CREEK, CA 94596
TEL: 925.938.7377
FAX: 925.938.7436



CAMPUS PROPERTY GROUP




Preliminary Landscape Plan

Creek Access & Boardwalk Enlargement

San Rafael, California

OCTOBER, 2019

L3

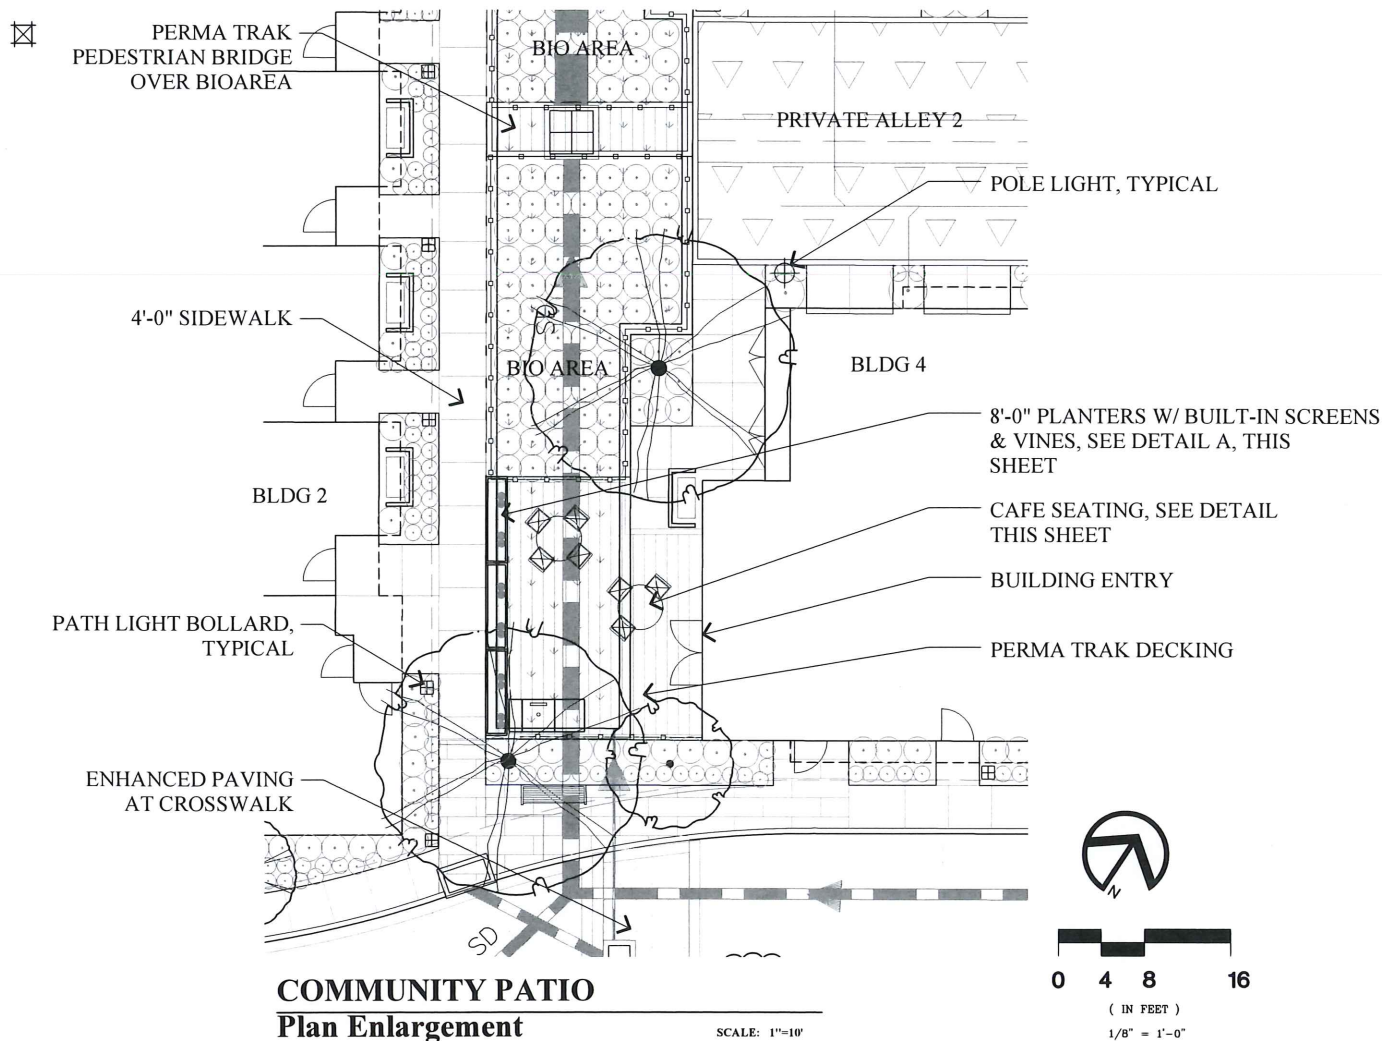

EXISTING TREE LEGEND

* REFER TO TREES INVENTORY


#	DATE	LOCATION	SPECIES	COMMON NAME	CANOPY HEIGHT	COND.	DECA	DEFECTS	COMMENTS
1	11/21/2018	ENTRANCE GATE AT DRAINAGE CANAL	PINUS MURICATA	BISHOP PINE	17.340	GOOD	N/A	NONE	THIN CANOPY, CALIF. NATIVE
2	1/21/2018	ENTRANCE GATE AT DRAINAGE CANAL	PINUS MURICATA	BISHOP PINE	13.540	FAIR	N/A	NONE	THIN CANOPY CALIF. NATIVE
3	1/21/2018	ENTRANCE GATE AT DRAINAGE CANAL	QUERCUS	COAST LIVE OAK	11	GOOD	N/A	NONE	MULTI STEM YOUNG TREE CALIF. NATIVE
4	1/21/2018	ENTRANCE GATE AT DRAINAGE CANAL	QUERCUS	COAST LIVE OAK	3.113	POOR	N/A	NONE	SINGLE TRUNK TREE CALIF. NATIVE - DEAD - TO BE REMOVED
5	1/21/2018	ALONG DRAINAGE CANAL E. PROPERTY	PINUS MURICATA	BISHOP PINE	10.740	POOR	N/A	NONE	PITCH FLOW & PINE BORERS BROWNING NEEDLES THROUGHOUT CANOPY REMOVE
6	1/21/2018	ARBOR AT SIDEWALK & BUILDING	JUNIPER OCCIDENTALIS	WESTERN JUNIPER	13.450	FAIR	N/A	NONE	STRUCTURE CONFLICT IMPACT CONFLICT BY BUILDING ARBOR & TRUNK REMOVAL NECESSARY
7	1/21/2018	EAST PARKING LOT PLANTER BED	QUERCUS	COAST LIVE OAK	6+2.1+2+2+2+45	GOOD	N/A	NONE	MULTI STEM TREE CALIF. NATIVE
8	1/21/2018	EAST PARKING LOT PLANTER BED	SEQUOIA	COASTAL REDWOOD	12.549	GOOD	N/A	NONE	CALIF. NATIVE TREE
9	1/21/2018	EAST PARKING LOT PLANTER BED	QUERCUS	COAST LIVE OAK	11.245	GOOD	N/A	NONE	CALIF. NATIVE TREE
10	1/21/2018	EAST PARKING LOT PLANTER BED	QUERCUS	COAST LIVE OAK	2.5+322	GOOD	N/A	NONE	2 STEMS, CALIF NATIVE
11	1/21/2018	EAST PARKING LOT PLANTER BED	SEQUOIA	COASTAL REDWOOD	13.345	GOOD	N/A	NONE	CALIF. NATIVE TREE
12	1/21/2018	EAST PARKING LOT PLANTER BED	SEQUOIA	COASTAL REDWOOD	3.56	GOOD	N/A	NONE	CALIF. NATIVE TREE
13	1/21/2018	N.E. CORNER AT DRAINAGE CANAL	QUERCUS	WHITE OAK	16.367	GOOD	N/A	NONE	STRESSED DECIDUOUS CALIF. NATIVE TREE
14	1/21/2018	PLANTER BED PARKING LOT	SEQUOIA	COASTAL REDWOOD	16.2+8.780	GOOD	N/A	NONE	DOUBLE STEM, CALIF. NATIVE TREE
15	1/21/2018	N.E. CORNER AT DRAINAGE CANAL	SEQUOIA	COASTAL REDWOOD	24.755	GOOD	N/A	NONE	SINGLE STEM TREE CALIF. NATIVE
16	1/21/2018	N.E. CORNER AT DRAINAGE CANAL	LIQUID AMBER	SWEETGUM	5.840	OK	N/A	NONE	INVASIVE ROOTS REMOVE TO ALLOW FOR REDWOOD DEVELOPMENT
17	1/21/2018	N.E. CORNER AT DRAINAGE CANAL	LIQUID AMBER	SWEETGUM	840	OK	N/A	NONE	INVASIVE ROOTS REMOVE TO ALLOW FOR REDWOOD DEVELOPMENT
18	1/21/2018	MID PARKING LOT NORTH PLANTER	UNKNOWN TREE DECIDUOUS		6.7+5.5+5.730	OK	N/A	NONE	MULTI STEM AT 3 FT. DBH
19	1/21/2018	MID PARKING LOT NORTH PLANTER	UNKNOWN TREE DECIDUOUS		6.525	OK	N/A	NONE	2 MAIN STEMS
20	1/21/2018	MID PARKING LOT NORTH PLANTER	UNKNOWN TREE DECIDUOUS		6+427	OK	N/A	NONE	2 MAIN STEMS FR. BASE OF TREE
21	1/21/2018	MID PARKING LOT NORTH PLANTER	UNKNOWN TREE DECIDUOUS		4+8.525	OK	N/A	NONE	
22	1/21/2018	PARKING LOT MERRYDALE RD.	SEQUOIA	COASTAL REDWOOD	23+1698	GOOD	N/A	NONE	2 COMPACTED STEMS TO BE REMOVED (15" & 6" DIA). TO ALLOW FOR MAIN TRUNKS DEVELOPMENT
23	1/21/2018	PARKING LOT MERRYDALE RD.	SEQUOIA	COASTAL REDWOOD	21.5+9.498	GOOD	N/A	NONE	2 TRUNKS FR. BASE CALIF. NATIVE TREE
24	1/21/2018	PARKING LOT MERRYDALE RD.	SEQUOIA	COASTAL REDWOOD	25.598	GOOD	N/A	NONE	SINGLE STEM TREE CALIF. NATIVE
25	1/21/2018	BEFORE MERRYDALE RD. BRIDGE	SEQUOIA	COASTAL REDWOOD	12.8,5,16.7,9.898-100	GOOD	N/A	NONE	CALIF. NATIVE TREES, GROUP MAY BE ALL ONE TREE CONNECTED ROOT SYSTEM.
26	1/21/2018	BEFORE MERRYDALE RD. BRIDGE	SEQUOIA	COASTAL REDWOOD	22.898	GOOD	N/A	NONE	CALIF. NATIVE TREE.
27	1/21/2018	BEFORE MERRYDALE RD. BRIDGE	SEQUOIA	COASTAL REDWOOD	2498	GOOD	N/A	NONE	CALIF. NATIVE TREE.
28	1/21/2018	BEFORE MERRYDALE RD. BRIDGE	SEQUOIA	COASTAL REDWOOD	2198	GOOD	N/A	NONE	CALIF. NATIVE TREE.
29	1/21/2018	BEFORE MERRYDALE RD. BRIDGE	SEQUOIA	COASTAL REDWOOD	1898	GOOD	N/A	NONE	CALIF. NATIVE TREE.
30	1/21/2018	BEFORE MERRYDALE RD. BRIDGE	SEQUOIA	COASTAL REDWOOD	24.898	GOOD	N/A	NONE	CALIF. NATIVE TREE.
31	1/21/2018	BETWEEN BUILDING SIDEWALK	ACER	MAPLE	912	FAIR-STRESSED	NONE	NONE	TREE IS IN PLANTER STRIP WITH TALL HEDGE DIVIDING SIDEWALK AND MERRYDALE RD. TREES ARE INSIGNIFICANT.
32	1/21/2018	BETWEEN BUILDING SIDEWALK	ACER	MAPLE	512	POOR-STRESSED	NONE	NONE	TREE IS IN PLANTER STRIP WITH TALL HEDGE DIVIDING SIDEWALK AND MERRYDALE RD. TREES ARE INSIGNIFICANT.
33	1/21/2018	BETWEEN BUILDING SIDEWALK	ACER	MAPLE	5	FAIR	NONE	NONE	TREE IS IN PLANTER STRIP WITH TALL HEDGE DIVIDING SIDEWALK AND MERRYDALE RD. TREES ARE INSIGNIFICANT.
34	1/21/2018	BETWEEN BUILDING SIDEWALK	PRUNUS FLOWER	ORNAMENTAL CHERRY	11.10.58	FAIR/POOR-STRESSED	NONE	NONE	CONDITION LIMITED SPACENONEBUCKLING SIDEWALK CONFLICT WITH UTILITY POLE
35	1/21/2018	BETWEEN BUILDING SIDEWALK	PRUNUS FLOWER	ORNAMENTAL CHERRY	2424	FAIR/POOR-STRESSED	NONE	NONE	PRUNING MAINTENANCE NECESSARY REMOVE BROKEN BRANCHES.
36	1/21/2018	FRONT SIDE YARD	PYRUS	FLOWERING PEAR	2035	FAIR	NONE	NONE	CONFLICT WITH CHAIN LINK FENCE. REMOVE TO ELIMINATE CONFLICT
37	1/21/2018	TO NEIGHBORING ELECTRIC SHOP	PYRUS	FLOWERING PEAR	1525	FAIR	NONE	NONE	15 FT.FAIRLOWER DEADWOODCONFINED SPACE
38	6/7/2019	SOUTH PROPERTY LINE	PRUNUS	ORNAMENTAL PEAR	4.4,4.15"	20 FT.GOODN/AGOODPRUNE DEADWOOD			
39	6/7/2019	SOUTH PROPERTY LINE	PRUNUS	ORNAMENTAL PEAR	5.8,2.5"	30 FTFAIRCONFLICT PUSHING PROPERTY LINE FENCE			
40	6/7/2019	SOUTH PROPERTY LINE	PRUNUS	ORNAMENTAL PEAR	15"	25 FTVERY POORTRUNK CANOPYDIEBACK SEVEREBEST REMOVED			
41	6/7/2019	SOUTH PROPERTY LINE	LIGUSTRUM	PRIVET	17.5"	45 FT. GOODN/AGOODPRUNE DEADWOOD			
42	6/7/2019	SOUTH PROPERTY LINE	PISTACIA	CHINESE PISTACHE	4.5,5"	30 FTFAIRCONFLICT PUSHING PROPERTY LINE FENCE			
43	6/7/2019	SOUTH PROPERTY LINE	POPULUS	EUROPEAN POPLAR	19"	25 FTVERY POORTRUNK CANOPYDIEBACK SEVEREBEST REMOVED			
44	6/7/2019	SOUTH PROPERTY LINE	POPULUS	EUROPEAN POPLAR	19"	35 FTFAIRWOUND SCAR WEST SIDE TRUNK & LIMBWOUND HEALINGNMISS LABELED MAPLE TREE PRUNING FOR DEADWOOD			




TOURNESOL TABLE W/ IPE TOPS




PERMA TRAK DECKING

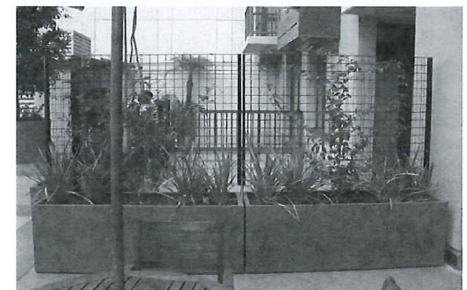


TOURNESOL WILSHIRE SCREEN

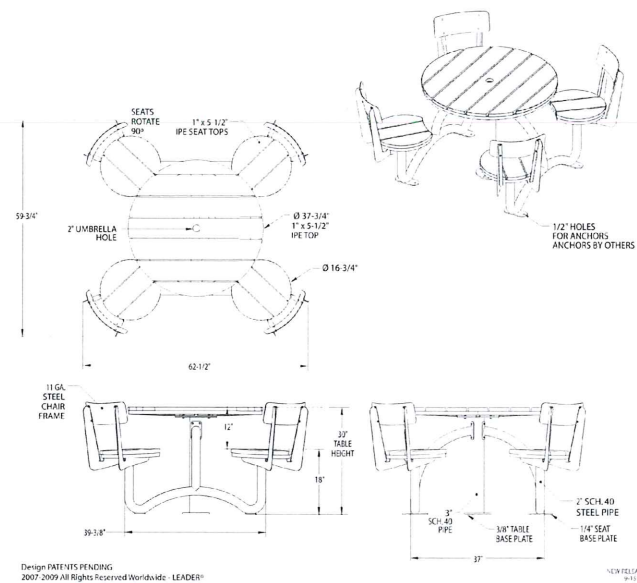

Model F-9 Picnic Table, with Ipe Tops

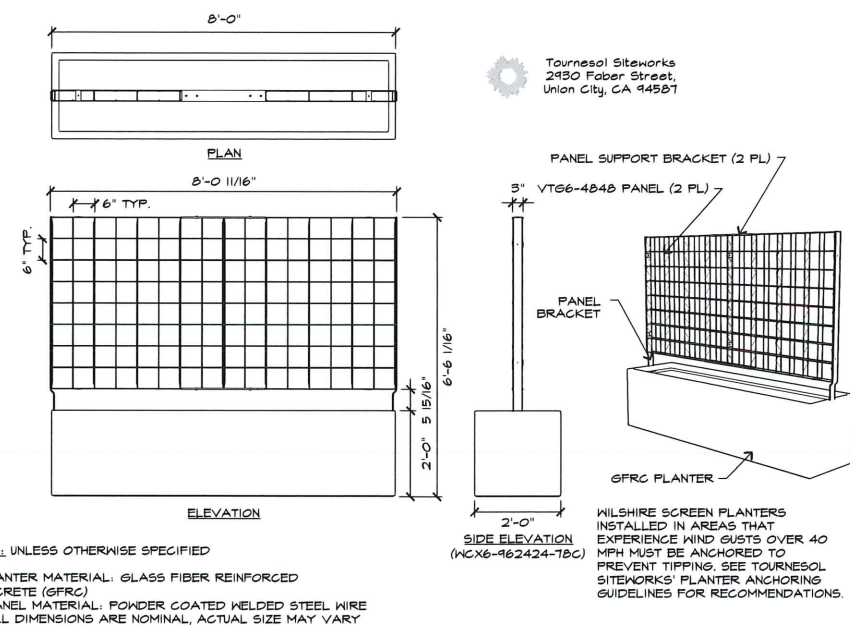

WILSHIRE SCREEN BY TOURNESOL SITEWORKS

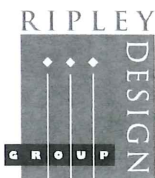

LANDSCAPE ARCHITECTURE
LAND PLANNING
1615 BONANZA STREET
SUITE 314
WALNUT CREEK, CA 94596
TEL: 925.938.7377
FAX: 925.938.7436

CAMPUS PROPERTY GROUP

Preliminary Landscape Plans

Patio Enlargement & Tree Inventory

350 Merrydale Rd

San Rafael, California


OCTOBER, 2019

L4




Quantity 22, Label B1, Arrangement Single, Lumens 2134, LLF 0.697, LDD 0.900, LLD 0.944, UDF 0.820, Sternberg BL-3-SL360-FG-26L27T2-F-MDL03-2.75', LUM 31.3



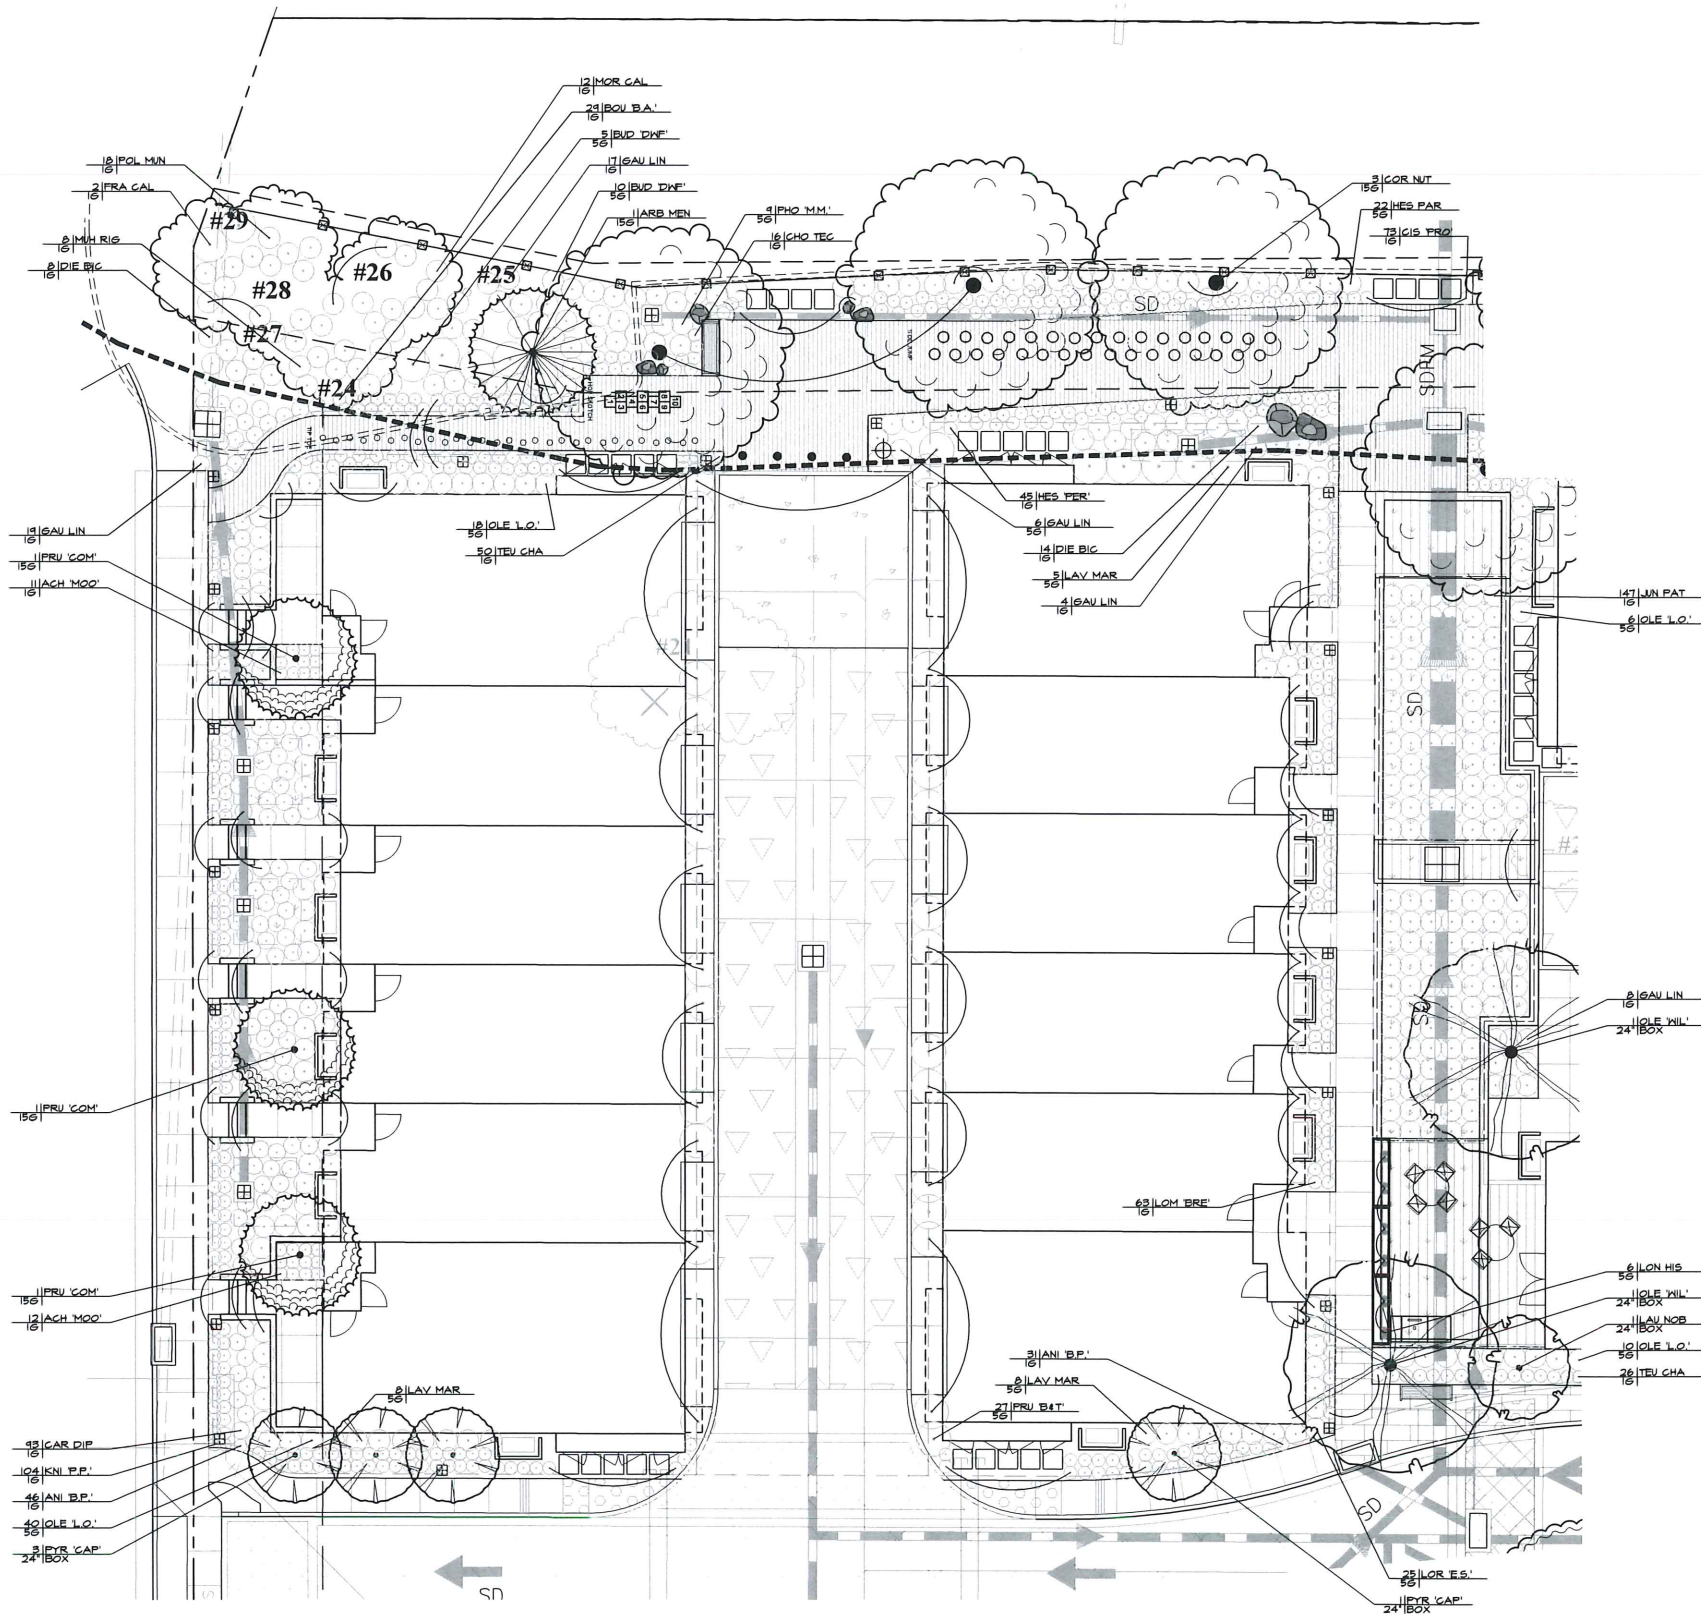

PRELIMINARY PROPOSED PLANT PALETTE

	EXISTING TREE TO REMAIN					
	# XXX					
	EXISTING TREE TO BE REMOVED					
	# XXX					
	SPECIMEN TREES					
	OLEA 'WILSONII'	WILSON OLIVE	24" BOX	25' WIDE/25' HIGH	LOW	3
	TRISTANIA CONFERTA	BRISBANE BOX	24" BOX	25' WIDE/30-40' HIGH	LOW-MEDIUM	5
	ACCENT TREES					
	PYRUS C. 'CAPITAL'	CAPITAL PEAR	24" BOX	12' WIDE/25' HIGH	LOW	7
	EVERGREEN TREES					
	ARBUTUS MARINA	STRAWBERRY TREE	24" BOX	20' WIDE/30' HIGH	LOW	6
	PRUNUS CAROLINIANA 'COMPACTA'	CAROLINA CHERRY	15 GALLON	15' WIDE/10' HIGH	LOW	13
	LAURUS NOBILIS	SWEET BAY	24" BOX	15' WIDE/15' HIGH	LOW	10
	BOARDWALK TREES					
	ARBUTUS MENZIESII	MADRONE	15 GALLON	30' WIDE/30' HIGH	LOW	1
	CORNUS NUTTALLII	PACIFIC DOGWOOD	15 GALLON	15' WIDE/15' HIGH	LOW	10
SYMBOL BOTANICAL NAME COMMON NAME SIZE WATER USE QUANTITIES						
	SHRUBS					
	ACH 'MOO'	ACHILLEA X 'MOONSHINE'	MOONSHINE YARROW	1 GALLON	LOW	58
	ANI 'B.P.'	ANIGONANTHOS 'BUSH PEARL'	DWARF KANGAROO PAW	1 GALLON	LOW	238
	BOU 'B.A.'	BOUTALOUA G. 'BLONDE AMBITION'	BLUE GRAMA GRASS	1 GALLON	LOW	144
	BUD 'DWI'	BUDDLEJA D. 'DWARF VARIETY'	DWARF BUTTERFLY BUSH	5 GALLON	LOW	24
	CHO 'TEC'	CHORONOPETALUM TECTORUM	CAPE RUSH	5 GALLON	LOW	38
	CIS 'PRO'	CISTUS S. 'PROSTRATUS'	SAGELEAF ROCKROSE	1 GALLON	LOW	231
	DIE 'BIC'	DIETES BICOLOR	FORTNIGHT LILY	1 GALLON	LOW	104
	FRA 'CAL'	FRANGULA CALIFORNICA	CALIFORNIA COFFEEBERRY	5 GALLON	LOW	2
	GAU 'LIN'	GAURA LINDHEIMERI	LINDHEIMER'S BEEBLOSSOM	1 GALLON	LOW	88
	HES 'PAR'	HESPERALOE PARVIFLORA	RED YUCCA	5 GALLON	LOW	73
	HES 'PER'	HESPERALOE P. 'PERPA'	BRAKELIGHTS RED YUCCA	1 GALLON	LOW	219
	KNI 'P.P.'	KNIPHOFIA 'PINEAPPLE POPSICLE'	RED HOT POCKER	1 GALLON	LOW	213
	LAV 'MAR'	LAVATERA MARITIMA	TREE MALLOW	5 GALLON	LOW	99
	LOM 'BRE'	LOMANDRA L. 'BREEZE'	DWARF MAT RUSH	1 GALLON	LOW	214
	LOR 'E.S.'	LOROPETALUM 'EMERALD SNOW'	CHINESE FRINGE FLOWER	5 GALLON	LOW	94
	MOR 'CAL'	MORELLA CALIFORNICA	CALIFORNIA WAX MYRTLE	1 GALLON	LOW	20
	MUH 'RIG'	MUHLBERGIA RIGENS	DEER GRASS	5 GALLON	LOW	13
	OLE 'L.O.'	OLEA E. 'LITTLE OLLIE'	DWARF OLIVE	5 GALLON	LOW	186
	PHO 'M.M.'	PHORMIUM T. 'MAORI MAIDEN'	NEW ZEALAND FLAX	1 GALLON	LOW	9
	POL 'MUN'	POLYSTICHUM MUNITUM	WESTERN SWORD FERN	1 GALLON	LOW	18
	PRU 'B&T'	PRUNUS BRIGHT & TIGHT	BRIGHT & TIGHT LAUREL	5 GALLON	LOW	78
	TEU 'CHA'	TEUCHRIUM CHAMAEDRYS	GERMANDER	1 GALLON	LOW	116
	XYL 'COM'	XYLOSMA C. 'COMPACTA'	COMPACT XYLOSMA	5 GALLON	LOW	72
	VINES					
	LON 'HIS'	LONICERA HISPIDULA	HAIRY HONEYSUCKLE	5 GALLON	LOW	6
	SHRUBS - BIO-RETENTION					
	BUD 'DWI'	BUDDLEJA 'DWARF VARIETIES'	DWARF BUTTERFLY BUSH	1 GALLON	LOW	15
	CAR 'DIP'	CAREX DIPSACEA	AUTUMN SEDGE	1 GALLON	LOW	175
	JUN 'PAT'	JUNCUS PATENS	CALIFORNIA RUSH	1 GALLON	LOW	210

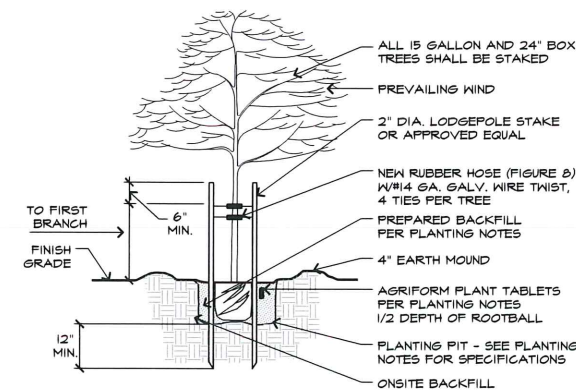

NOTE:
1. ROOT CONTROL BARRIER PANELS SHALL BE REQUIRED WHERE TREES IS WITHIN 10' FROM PAVING. ROOT SOLUTIONS ROOT BARRIER OR EQUAL MAY BE USED. LENGTH OF BARRIER TO BE CENTERED ON TREE.

A TREE PLANTING AND STAKING DETAIL SCALE: 1/2" = 1'-0"

PLANT CALLOUT SYMBOL KEY	
PLANT QTY	PLANT SYMBOL
SIZE	UNITS





PLANT CALLOUT SYMBOL KEY

350 Merrydale Rd

San Rafael, California

OCTOBER, 2019


L7

PLANTING NOTES

1. THE CONTRACTOR SHALL MAINTAIN A QUALIFIED SUPERVISOR ON THE SITE AT ALL TIMES DURING CONSTRUCTION THROUGH COMPLETION OF PICK-UP WORK.
2. THE CONTRACTOR SHALL FURNISH AND PAY FOR ALL FORMS OF PLANT MATERIALS AND SPECIFIED INSTALLATIONS, INCLUDING FLATTED GROUNDCOVER.
3. THE LANDSCAPE CONTRACTOR SHALL BE RESPONSIBLE FOR LOCATION AND STAKING ALL SEWER, UTILITY AND WATER MAIN LINES PRIOR TO PLANTING. LANDSCAPE CONTRACTOR SHALL ASSUME SOLE RESPONSIBILITY FOR ANY COSTS INCURRED DUE TO DAMAGE AND REPLACEMENT OF SAID UTILITIES. CALL COMMON GROUND ALLIANCE (CGA) AT 811 TO LOCATE AND MARK UTILITIES PRIOR TO EXCAVATION.
4. SOIL PREPARATIONS: GROUNDCOVER AND TURF AREAS SHALL BE CROSSRIPPED OR TILLED TO A DEPTH OF NINE (9) INCHES. THE AMENDMENT SHALL BE UNIFORMLY BROADCAST PER 1,000 S.F. AND THOROUGHLY INCORPORATED TO A DEPTH OF 9" BY MEANS OF ROTOTILLER OR EQUAL. THE FOLLOWING FORMULA SHALL BE USED FOR BIDDING PURPOSES ONLY:
6 CU.YDS. ORGANIC COMPOST
35 LBS. 6-20-20 COMMERCIAL FERTILIZER
50 LBS. IRON SULFATE (20% Fe)
5. BACKFILL FOR TREES AND SHRUBS: THE PLANTING PITS FOR TREES AND SHRUBS SHALL BE EXCAVATED TO TWICE THE DIAMETER AND TO THE DEPTH OF THE ROOTBALL. ON SITE SOIL SHALL BE USED FOR BACKFILL PURPOSES. THE FOLLOWING MIX SHALL BE USED FOR BIDDING PURPOSES ONLY:
6 PARTS BY VOLUME ON SITE SOIL
4 PARTS BY VOLUME ORGANIC AMENDMENT PER ABOVE
2LB./CU.YD. OF MIX 6-20-20
2LB./CU.YD. OF MIX IRON SULFATE PER CU.YD. OF MIX
6. ALL SOIL AMENDMENTS SPECIFIED ARE FOR BIDDING PURPOSES ONLY. ONCE SITE HAS BEEN ROUGH GRADED, CONTRACTOR SHALL OBTAIN A SOILS REPORT FROM WAYPOINT ANALYTICAL CALIFORNIA, INC. (408-727-0330) FOR SOIL AMENDMENTS. CONTRACTOR TO SUBMIT ONE COPY OF THE SOILS REPORT TO THE CITY, ONE COPY TO THE OWNER, AND ONE COPY TO THE LANDSCAPE ARCHITECT FOR USE IN PROVIDING UPDATED IRRIGATION SCHEDULING RECOMMENDATIONS TO BE INCLUDED PRIOR TO APPROVAL OF CERTIFICATE OF COMPLIANCE. CONTRACTOR SHALL FOLLOW THE SOIL PREPARATION AND BACKFILL MIX PER THE REPORT.
7. ALL 5 GALLON SHRUBS SHALL RECEIVE TWO (2) 21 GRAM AGRIFORM PLANTING TABLETS, ALL 15 GALLON TREES SHALL RECEIVE FOUR (4) 21 GRAM AGRIFORM PLANTING TABLETS AND ALL BOX TREES SHALL RECEIVE EIGHT (8) 21 GRAM AGRIFORM TABLETS.
8. ALL SHRUB AND GROUNDCOVER PLANTING AREAS SHALL BE MULCHED TO A MINIMUM DEPTH OF 3". MULCH TO BE RECYCLED WOOD WASTE, COLOR TO BE BLACK, ¼" TO 1" DIAMETER FROM WASTE MANAGEMENT, INC., SACRAMENTO, (916-452-0142).
9. CONTRACTOR SHALL SPRAY ALL EXISTING WEEDS IN PLANTING AREAS PRIOR TO RIPPING AND APPLY PRE-EMERGENT TO ALL SHRUB AREAS AFTER PLANTING.
10. CONTRACTORS SHALL APPLY FERTILIZER AND PRE-EMERGENT AT END OF MAINTENANCE PERIOD.
11. LANDSCAPE ARCHITECT AND/ OR OWNER RESERVES THE RIGHT TO SELECT OR REJECT ANY OR ALL PLANT MATERIAL.
12. REFER TO TREE PLANTING/STAKING DETAIL A, SHEET LP.3.
13. THIS PLAN COMPLIES WITH THE CRITERIA OF THE CITY'S WATER EFFICIENT LANDSCAPE ORDINANCE AND APPLIES THEM FOR THE EFFICIENT USE OF WATER IN THE LANDSCAPE DESIGN PLAN.

TREE REMOVAL

A TOTAL OF 43 MATURE TREES OF VARYING CONDITION ARE LOCATED ON THE PROJECT SITE AND (1) TREE THAT IS DEAD. ALL TREES HAVE BEEN PROPOSED FOR REMOVAL EXCEPT THE GROVE OF REDWOODS ON THE NORTHWEST (6) AND NORTHEAST (2) CORNERS OF THE PROJECT SITE, (3) IN THE SOUTHERN MOST CORNER OF THE PROPERTY LINE AND THE BISHOP PINES (2) AND COAST LIVE OAK (1) AT THE REDWOOD HIGHWAY ENTRY. THE TREES PROPOSED FOR REMOVAL ARE HIGHLIGHTED ON THE TREE INVENTORY. THERE IS A TOTAL OF 28 TREES PROPOSED FOR REMOVAL.

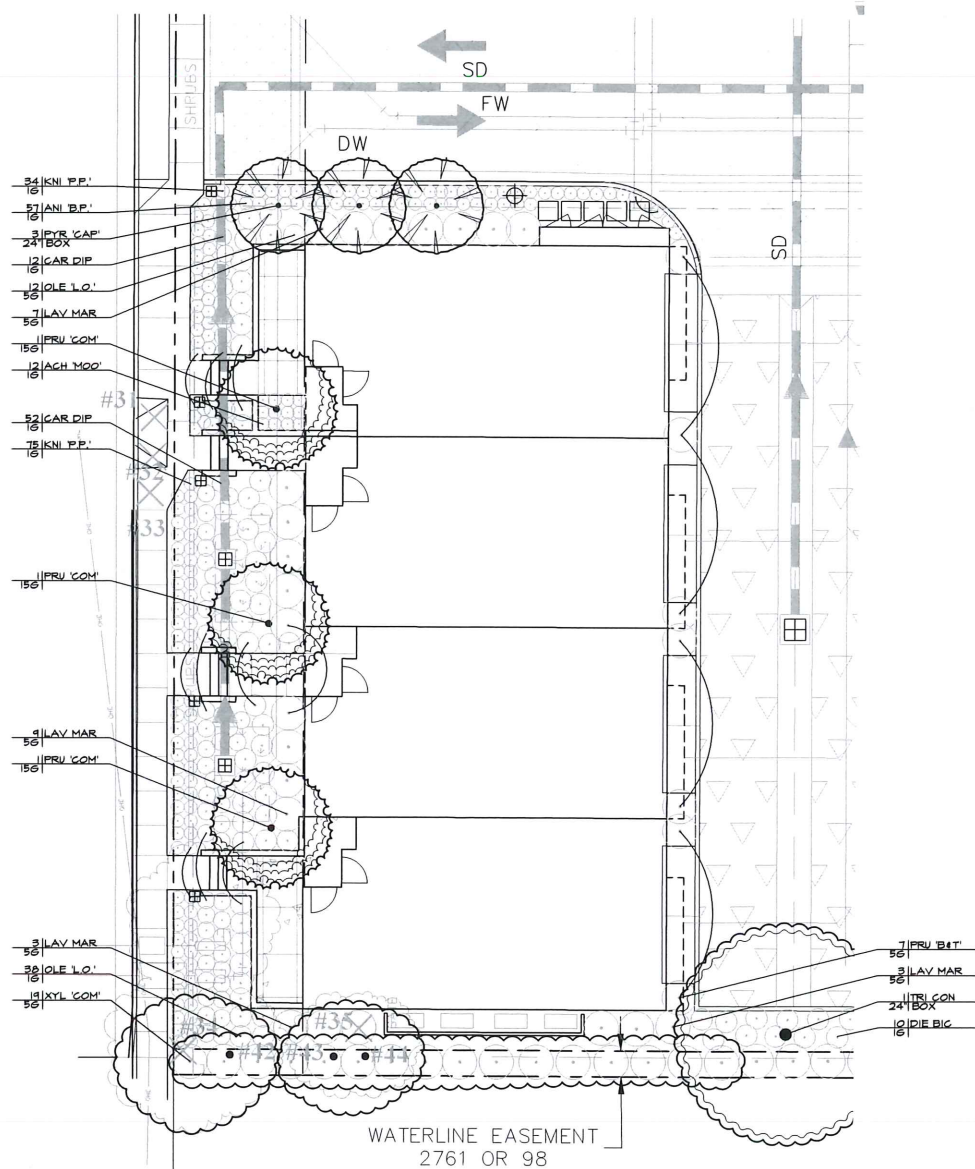

PRELIMINARY PROPOSED PLANT PALETTE

EXISTING TREE TO REMAIN # XXX						
EXISTING TREE TO BE REMOVED #XXX						
SPECIMEN TREES						
OLEA 'WILSONII'	WILSON OLIVE	24" BOX	25' WIDE/25' HIGH	LOW	3	
TRISTANIA CONFERTA	BRISBANE BOX	24" BOX	25' WIDE/30-40' HIGH	LOW-MEDIUM	5	
ACCENT TREES						
PYRUS C. 'CAPITAL'	CAPITAL PEAR	24" BOX	12' WIDE/25' HIGH	LOW	7	
EVERGREEN TREES						
ARBUTUS MARINA	STRAWBERRY TREE	24" BOX	20' WIDE/30' HIGH	LOW	6	
PRUNUS C. 'COMPACTA'	CAROLINA CHERRY	15 GALLON	15' WIDE/10' HIGH	LOW	13	
LAURUS NOBILIS	SWEET BAY	24" BOX	15' WIDE/15' HIGH	LOW	10	
BOARDWALK TREES						
ARBUTUS MENZIESII	MADRONE	15 GALLON	30' WIDE/30' HIGH	LOW	1	
CORNUS NUTTALLII	PACIFIC DOGWOOD	15 GALLON	15' WIDE/15' HIGH	LOW	10	
SYMBOL	BOTANICAL NAME	COMMON NAME	SIZE	WATER USE	QUANTITIES	
SHRUBS						
ACH 'MOO'	ACHILLEA X 'MOONSHINE'	MOONSHINE YARROW	1 GALLON	LOW	58	
ANI 'B.P.'	ANIGOSANTHOS 'BUSH PEARL'	DWARF KANGAROO PAW	1 GALLON	LOW	238	
BOU 'B.A.'	BOUTALOUA G. 'BLONDE AMBITION'	BLUE GRAMA GRASS	1 GALLON	LOW	144	
BUD 'DWF'	BUDDLEJA D. 'DWARF VARIETY'	DWARF BUTTERFLY BUSH	5 GALLON	LOW	24	
CHO 'TEC'	CHORONDOPTALUM TECTORUM	CAPE RUSH	5 GALLON	LOW	38	
CIS 'PRO'	CISTUS S. 'PROSTRATUS'	SAGELEAF ROCKROSE	1 GALLON	LOW	231	
DIE 'BIC'	DIEYES BICOLOR	FORTNIGHT LILY	1 GALLON	LOW	104	
FRA CAL	FRANGULA CALIFORNICA	CALIFORNIA COFFEEBERRY	5 GALLON	LOW	2	
GAU LIN	GAURA LINDHEIMERI	LINDHEIMER'S BEEFBLOSSOM	1 GALLON	LOW	88	
HES PAR	HESPERALOE PARVIFLORA	RED YUCCA	5 GALLON	LOW	73	
HES 'PER'	HESPERALOE P. 'PERPA'	BRACKETLIGHTS RED YUCCA	1 GALLON	LOW	219	
KNI 'P.P.'	KNIPHOFIA 'PINEAPPLE POPSICLE'	RED HOT POCKER	1 GALLON	LOW	213	
LAV MAR	LAVATERA MARITIMA	TREE MALLOW	5 GALLON	LOW	99	
LOM 'BRE'	LOMANDRA L. 'BREEZE'	DWARF MAT RUSH	1 GALLON	LOW	214	
LOR 'E.S.'	LOROPETALUM 'EMERALD SNOW'	CHINESE FRINGE FLOWER	5 GALLON	LOW	94	
MOR CAL	MORELLA CALIFORNICA	CALIFORNIA WAX MYRTLE	1 GALLON	LOW	20	
MUH RIG	MUHLENBERGIA RIGENS	DEER GRASS	5 GALLON	LOW	13	
OLE 'L.O.'	OLEA E. 'LITTLE OLIE'	DWARF OLIVE	5 GALLON	LOW	186	
PHO 'M.M.'	PHORMIUM T. 'MAORI MAIDEN'	NEW ZEALAND FLAX	5 GALLON	LOW	9	
POL MUN	POLYSTICHUM MUNITUM	WESTERN SWORD FERN	1 GALLON	LOW	18	
PRU 'BBI'	PRUNUS 'BRIGHT & TIGHT'	BRIGHT & TIGHT LAUREL	5 GALLON	LOW	78	
TEU OHA	TEUCHORIUM CHAMAEDRY'S	GERMANIER	1 GALLON	LOW	116	
XYL 'COM'	XYLOSMA C. 'COMPACTA'	COMPACT XYLOSMA	5 GALLON	LOW	72	
VINES						
LON HIS	LONICERA HISPIDULA	HAIRY HONEYSUCKLE	5 GALLON	LOW	6	
SHRUBS - BIO-RETENTION						
BUD 'DWF'	BUDDLEJA 'DWARF VARIETIES'	DWARF BUTTERFLY BUSH	1 GALLON	LOW	15	
CAR DIP	CAREX DIPSACEA	AUTUMN SEDGE	1 GALLON	LOW	175	
JUN PAT	JUNCUS PATENS	CALIFORNIA RUSH	1 GALLON	LOW	210	

PLANT CALLOUT SYMBOL KEY

PLANT QTY	PLANT SYMBOL
SIZE	UNITS


350 Merrydale Rd

San Rafael, California

OCTOBER, 2019

L9



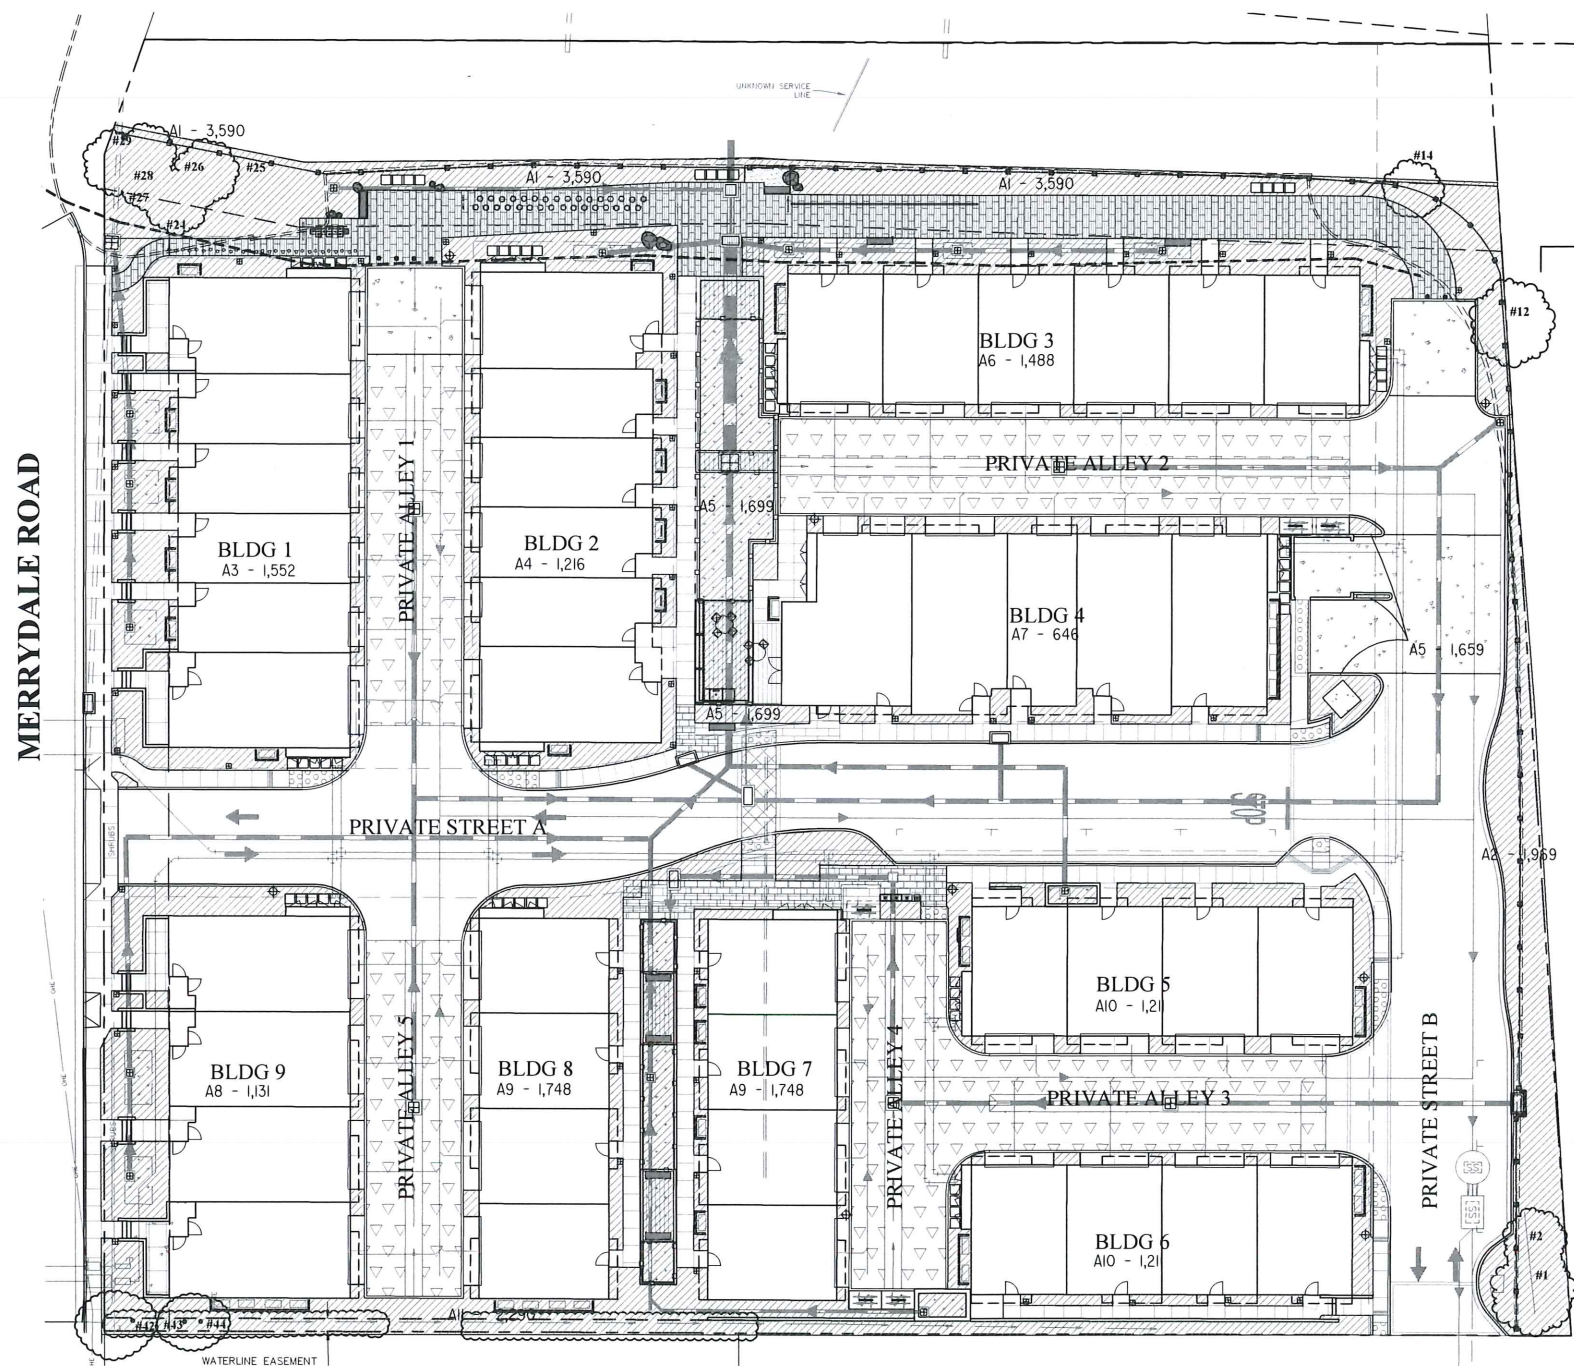

WATER USE CALCULATIONS:

THE MAXIMUM APPLIED WATER ALLOWANCE (MAWA) IN GALLONS PER YEAR IS BASED ON THE FOLLOWING FORMULA:

$$MAWA = (ETO)(0.62)(0.55 \times LA)$$

THE ESTIMATED TOTAL WATER USE (ETWU) IS THE SUM TOTAL OF ESTIMATED WATER USE FOR EACH HYDROZONE IN GALLONS PER YEAR AND IS BASED ON THE FOLLOWING FORMULA:

$$ETWU = (ETO)(0.62)(PF \times HA + SLA)$$

ETO = REFERENCE EVAPOTRANSPIRATION (INCHES PER YEAR)
LA = LANDSCAPE AREA
HA = HYDROZONE AREA (SQUARE FEET)
PF = PLANT FACTOR FROM WUCOLS
IE = IRRIGATION EFFICIENCY (0.8)
0.55 = ET ADJUSTMENT FACTOR
0.62 = CONVERSION FACTOR (TO GALLONS)

REFERENCE EVAPOTRANSPIRATION (ETO) : 35.8

MAXIMUM APPLIED WATER ALLOWANCE: 270,329 GAL/YR

$$MAWA = (35.8) \times (0.62) \times (0.55 \times 22,441) = 270,329 \text{ GAL/YR}$$

ESTIMATED TOTAL WATER USE: 134,642 GAL/YR

$$LOW \text{ ETWU} = (35.8) \times (0.62) \times (0.20 \times 18,426) = 100,984 \text{ GAL/YR}$$

HYDROZONE KEY

SYMBOL	DESCRIPTION
	18,426 SF LOW WATER USE

HYDROZONE INFORMATION TABLE

HYDROZONE (WATER USE)	ZONE/ VALVE	IRRIQ. METHOD	AREA	% OF LANDSCAPE AREA
LOW	A-1	DRIP	3,590 SF	19.44%
LOW	A-2	DRIP	1,969 SF	10.66%
LOW	A-3	DRIP	1,552 SF	8.41%
LOW	A-4	DRIP	1,216 SF	6.59%
LOW	A-5	DRIP	1,659 SF	8.06%
LOW	A-6	DRIP	1,488 SF	7.9%
LOW	A-7	DRIP	572 SF	3.1%
LOW	A-8	DRIP	1,131 SF	6.12%
LOW	A-9	DRIP	1,748 SF	9.47%
LOW	A-10	DRIP	1,211 SF	6.56%
LOW	A-11	DRIP	2,290 SF	12.4%
TOTAL			18,426 SF	100%

HYDROZONES


NAME	TYPE	WATER USE	DESCRIPTION
360 MERRYDALE ROAD			
A-1	DRIP	LOW	SHRUBS-BETWEEN ACCESS ROAD PLAZA & EXISTING CREEK RIFF RAFF
A-2	DRIP	LOW	SHRUBS-MEDIAN ALONG PRIVATE ROAD 'B'
A-3	DRIP	LOW	SHRUBS-SURROUNDING BUILDING 1
A-4	DRIP	LOW	SHRUBS-SURROUNDING BUILDING 2
A-5	DRIP	LOW	SHRUBS-BIO RETENTION BASIN & FRONTAGE AT BUILDING 4
A-6	DRIP	LOW	SHRUBS-NORTHERN/EASTERN EXPOSURES-SOUTH SIDE OF TRAILER
A-7	DRIP	LOW	GROUNDCOVER-FERRY LAUNCH ROAD PARKWAY-SOUTHERN 1/3
A-8	DRIP	LOW	GROUNDCOVER-FERRY LAUNCH ROAD-PRIVATE PROPERTY
A-9	DRIP	LOW	SHRUBS-FERRY LAUNCH ROAD-SOUTHERN/WESTERN EXPOSURES
A-10	DRIP	LOW	TREES-FERRY LAUNCH ROAD-PUBLIC PARKWAY
A-11	DRIP	LOW	GROUNDCOVER-FERRY LAUNCH ROAD PARKWAY-MIDDLE 1/3
A-12	DRIP	LOW	SHRUBS-SHARED SPACE BETWEEN PROPERTY LINE & BUILDINGS 6,7,8,9

350 Merrydale Rd

San Rafael, California

OCTOBER, 2019

L10

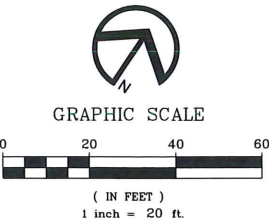


RIPLEY
DESIGN
GROUP
LANDSCAPE ARCHITECTURE
LAND PLANNING
1615 BONANZA STREET
SUITE 314
WALNUT CREEK, CA 94596
TEL: 925.938.7377
FAX: 925.938.7436


CAMPUS PROPERTY GROUP
Water Efficient Landscape Ordinance
& Landscape Data

Luminaire Schedule										
Project: 350 MERRYDALE RD - 3RS SCHOOL SITE										
Symbol	Qty	Label	Arrangement	Lum. Lumens	LLF	LOD	LLD	UDF *	Description	Filename
	6	A	SINGLE	4308	0.807	0.900	0.944	0.950	STERNBERG SL660-12L30T2-MDL018-CA-BLOC - 12' L.C.	SL660-12L40T2-MDL018-CA-BLOC.IES *
	2	A1	SINGLE	4569	0.807	0.900	0.944	0.950	STERNBERG SL660-12L30T3-MDL018-CA-BLOC - 12' L.C.	SL660-12L40T3-MDL018-CA-BLOC.IES *
	9	B	SINGLE	2118	0.697	0.900	0.944	0.820	STERNBERG BL-3-SL360-FG-26L27T3-F-MDL03 - 2.75' L.C.	SL360-FG-26L45T3-F-MDL03.IES *
	40	B1	SINGLE	2134	0.697	0.900	0.944	0.820	STERNBERG BL-3-SL360-FG-26L27T2-F-MDL03 - 2.75' L.C.	SL360-FG-26L45T2-F-MDL03.IES *
	14	C	SINGLE	1799	0.850	0.900	0.944	N.A.	SIGNIFY GARDCO 111L-16L-350-NW-G2-3-VOLT - 10' M.H.	111L-16L-350-NW-G2-3.IES


* UDF FACTOR PRORATED TO SIMULATE 3000K & 2700K. PHOTOMETRY IS BASED ON 4000K & 4500K; PHOTOMETRY FOR 3000K & 2700K ARE NOT AVAILABLE AT THE TIME OF THIS ANALYSIS. FIELD RESULTS MAY VARY.

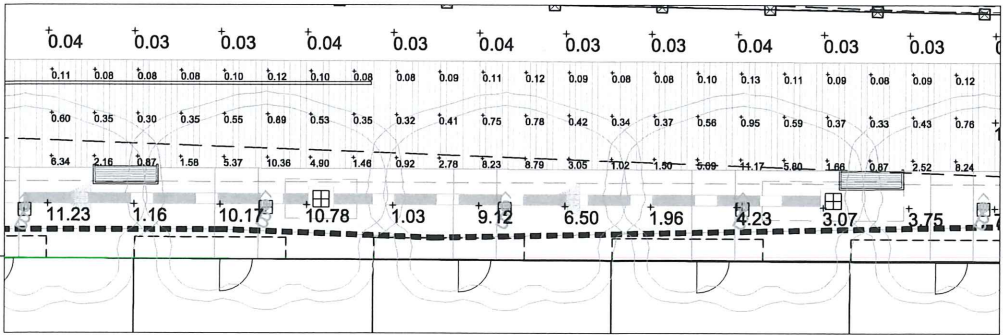



TYPICAL PATHWAY B
(IN FEET)
1/8" = 1'-0"

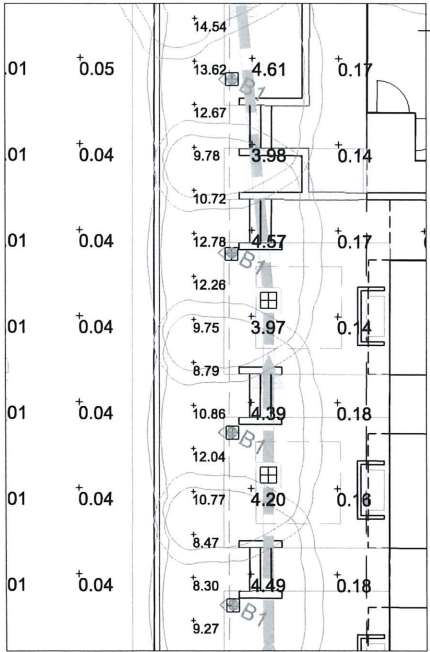

TYPICAL PATHWAY A

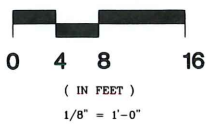

GRAPHIC SCALE

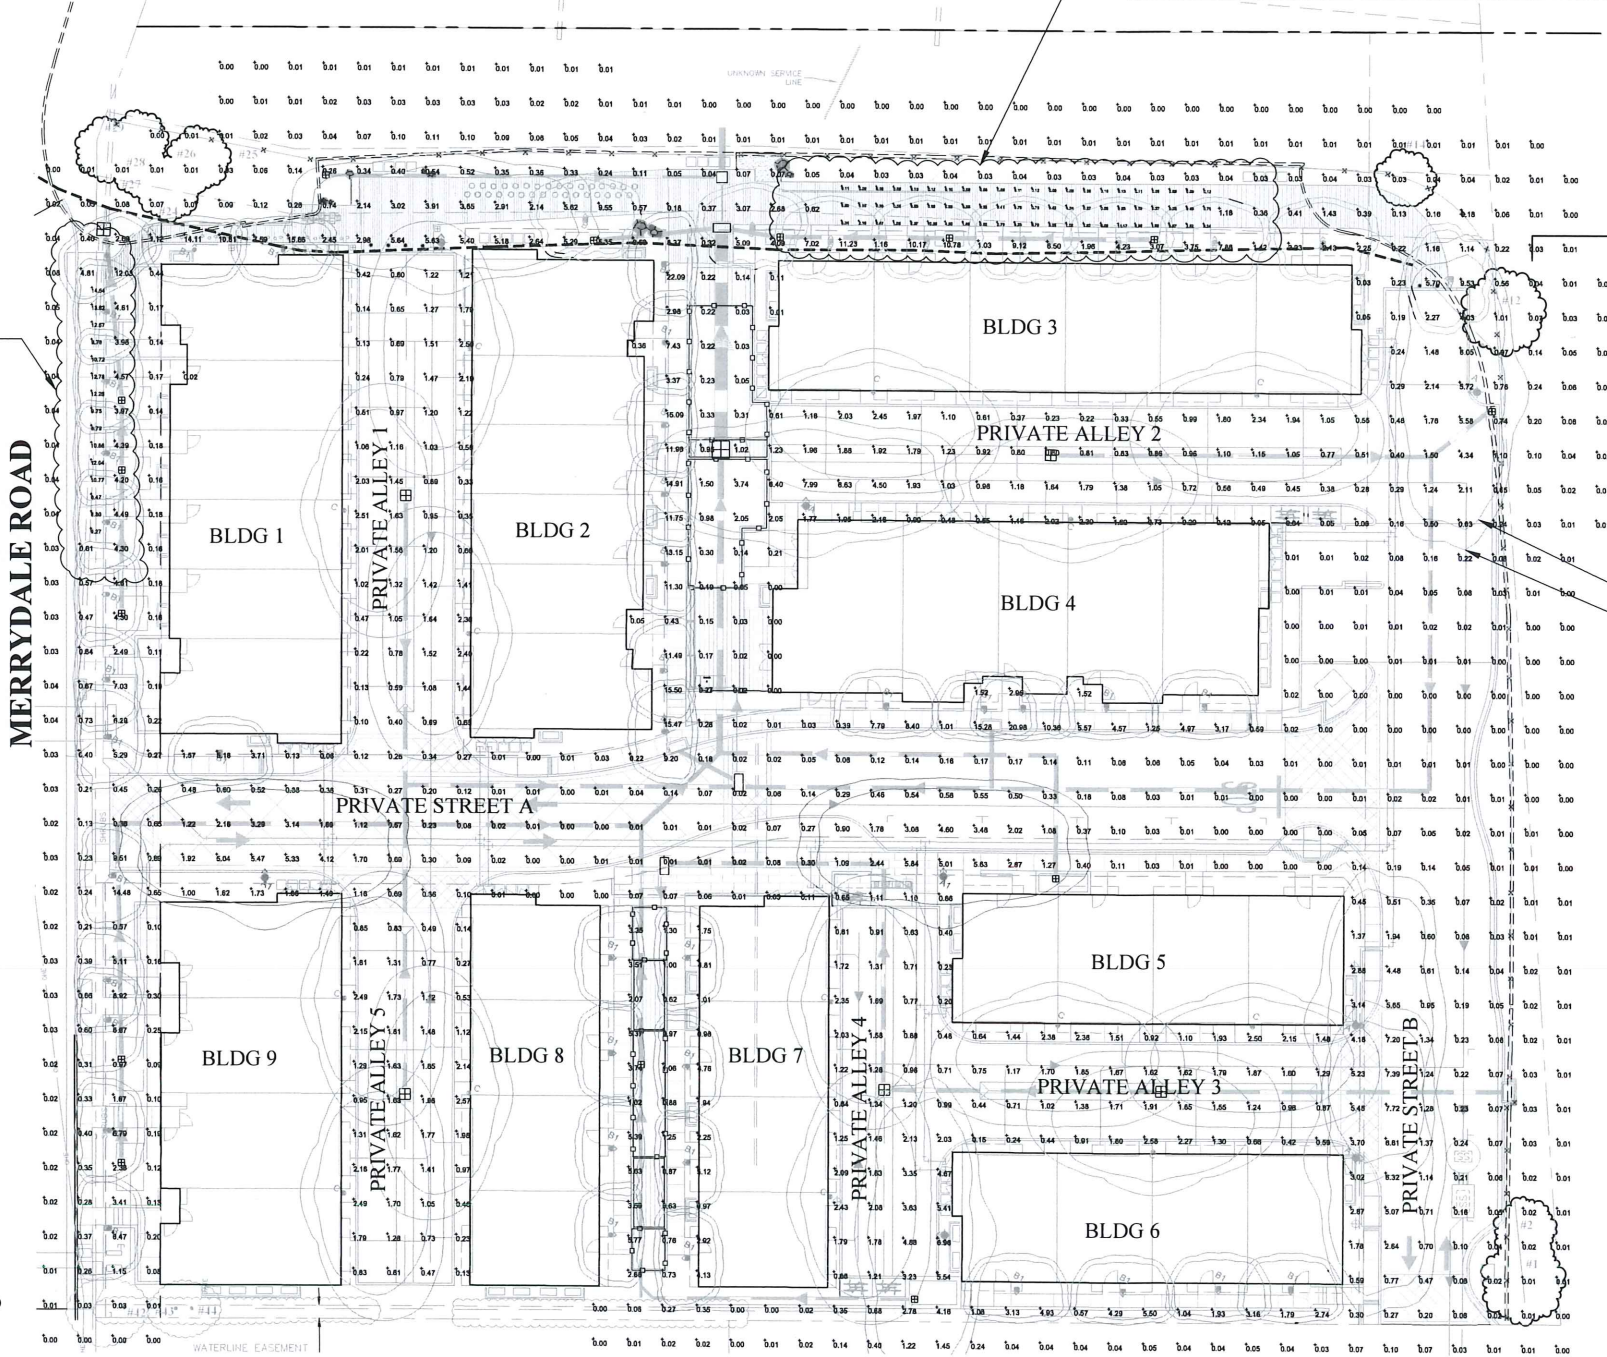 

Calculation Summary							
Project: 350 MERRYDALE RD - 3RS SCHOOL SITE							
Label	CalcType	Units	Avg	Max	Min	Avg/Min	Max/Min
TYPICAL PATHWAY A	Illuminance	Fc	10.97	14.54	8.30	1.32	1.75
TYPICAL PATHWAY B	Illuminance	Fc	1.64	11.17	0.08	20.50	139.63
PRIVATE STREET A	Illuminance	Fc	0.78	9.51	0.00	N.A.	N.A.

0.50FC
0.25FC

350 Merrydale Rd

RIPLEY
DESIGN
GROUP
LANDSCAPE ARCHITECTURE
LAND PLANNING
1615 BONANZA STREET
SUITE 314
WALNUT CREEK, CA 94596
TEL: 925.938.7377
FAX: 925.938.7436

CAMPUS PROPERTY GROUP
Photometric Lighting Plan
Prepared by ALR, Inc.

San Rafael, California

OCTOBER, 2019