



Appendix G


Utility Plan

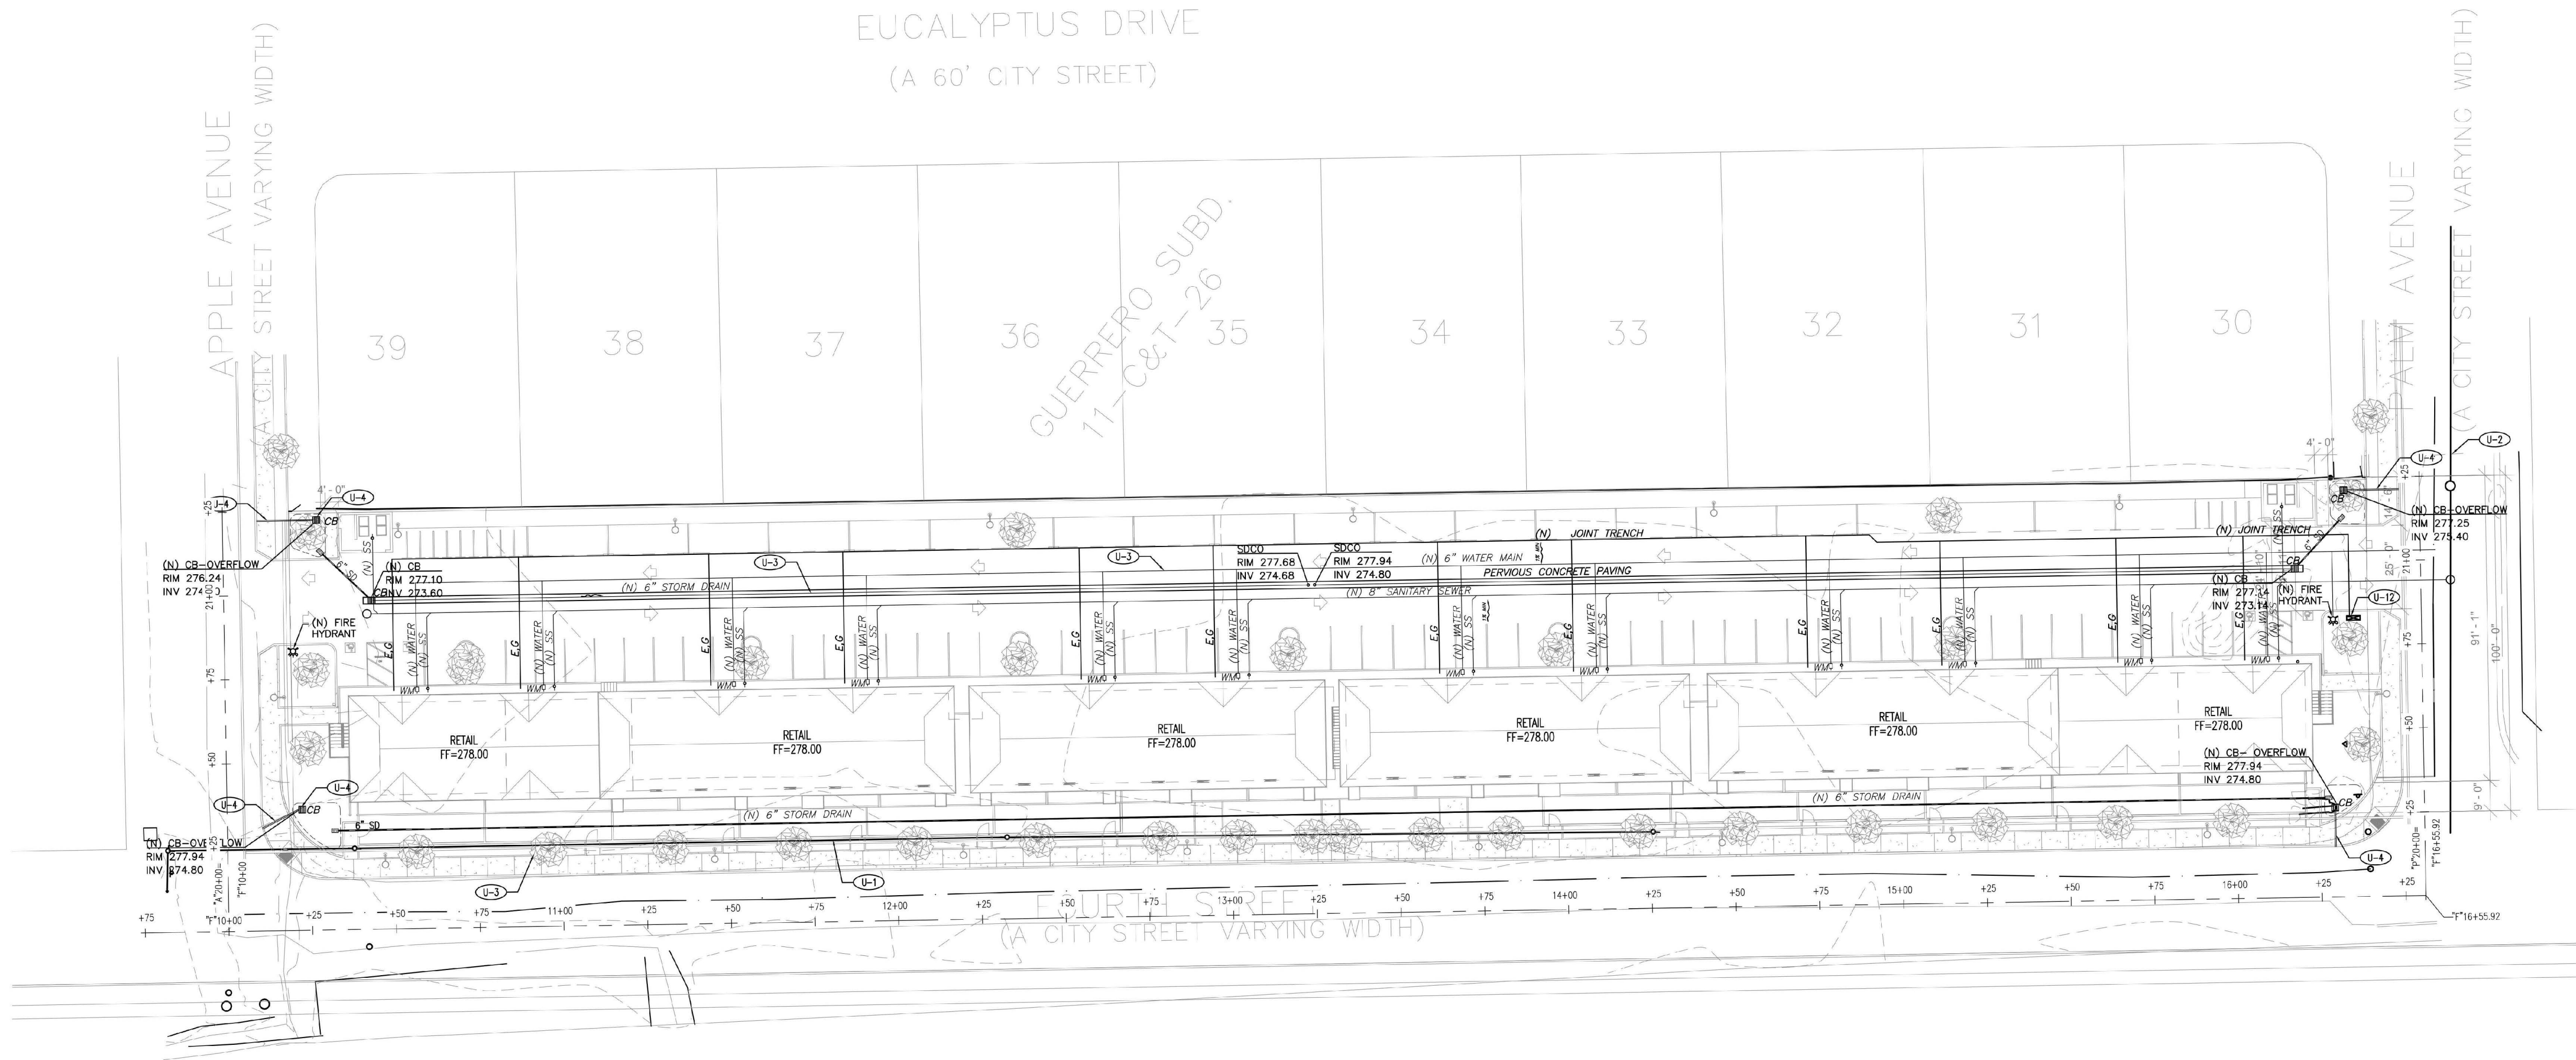

- UTILITY PLAN NOTES**
- U-1 (E) OVERHEAD ELECTRIC LINE TO BE UNDERGROUNDED.
 - U-2 (E) SANITARY SEWER MAIN.
 - U-3 (N) PRIVATE SANITARY SEWER LATERAL.
 - U-4 (N) WATER MAIN.
 - U-5 (N) STORM DRAIN PIPE (RCP).
 - U-6 (N) SANITARY SEWER CLEANOUT.
 - U-7 (N) OVERFLOW CATCH BASIN.
 - U-8 (N) WATER METER (TYP).
 - U-9 (N) BIOTENTION BASIN.
 - U-10 (N) WATER SERVICE LINE.
 - U-11 (N) JOINT TRENCH.
 - U-12 (N) TRANSFORMER.
 - U-13 (N) STORM DRAIN OVERFLOW STRUCTURE.

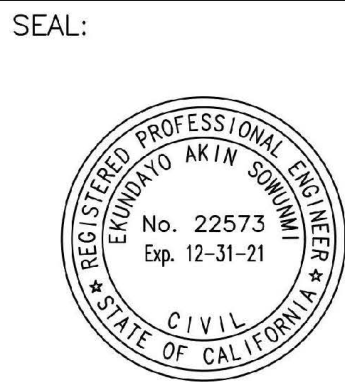

ACKLAND
INTERNATIONAL, INC. Suite 206
333 Hegenberger Road
Oakland, CA 94621
510.633.2431 (tel)
510.633.2431 (fax)

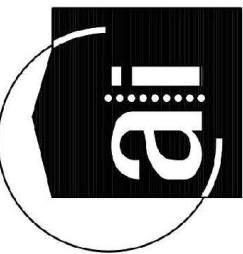

PROJECT NAME:
**MIXED RETAIL & RESIDENTIAL
FOURTH STREET
GREENFIELD, CA 93927**

CLIENT NAME & ADDRESS:
**MR EDUARDO COUTTOLENC
354 UNIVERSITY AVE
SALINAS, CA 93901**

NO.	DATE	DESCRIPTION	BY
1	07/14/20		

SHEET TITLE
UTILITY PLAN

PROJECT NO. S20038

DRAWN BY: EU

CHECKED BY: ES

SCALE: AS SHOWN

DATE: 01-31-21

SHEET NO.

C4.0

CALIFORNIA HIGHWAY ROUTE US101

UTILITY PLAN

SCALE: 1" = 10'- 0"

