



PUTAH STORAGE, LLC.

MAJOR USE PERMIT

SRA AREA: = YES
FLOOD ZONE: = X ZONE

PARKING SUMMARY		
TYPE OF PARKING SPACE	SPACES REQUIRED	SPACES PROVIDED
STANDARD (9' x 18')	22	22
ADA VAN ACCESSIBLE (9' x 18' WITH 8' ACCESS AISLE)	1	1
	23 TOTAL SPACES REQ'D	23 TOTAL SPACES PROVIDED

PARKING LOAD CALCULATIONS: (LAKE SEC 21-46)			
LOCATION	AREA (SQ.FT.)	LOAD FACTOR	PARKING REQ'D (SPACES)
STORAGE/MANUFACTURING (S-1/F-1)	10,969 SQ.FT. 15 EMPLOYEES	1 PER 600 SQ.FT. OR 1 PER EMPLOYEE	18.3 15
OFFICE & BATHROOMS (B)	1,031 SQ.FT.	1 PER 250 SQ.FT.	4.1
	TOTAL = 12,000 SQ. FT.		TOTAL = 23 SPACES REQUIRED

22x34 SHEET: 1"=70'
11x17 SHEET: 1"=140'

A horizontal graphic scale bar with a black and white alternating pattern. It is marked with the numbers 0, 35, 70, and 140, representing feet.



Avoid cutting underground utility lines. It's costly.

**Call
before you
Dig**

**811 OR 800-642-2444
UNDERGROUND SERVICE (USA)**

SEE PRELIMINARY STORMWATER CONTROL PLAN FOR
DRAINAGE AND LANDSCAPING INFORMATION

[illegible]

NORTHPOINT
CONSULTING GROUP, INC.
1117 Samoa Blvd., Arcata, CA 95521

PUTAH STORAGE, LLC

18830 PUTAH LN., MIDDLETOWN, CA 95467 / APN:014-500-03

PLOT PLAN, VICINITY MAP, AND PROJECT NOTES


PROJ. MGR.: SN
DRAWN BY: TJS
DATE: 11/21/22
SCALE: AS SHOWN

SHEET

CO

22-061


November 23, 2022 - 14:57 Draw Name: P:\Putah Storage - 22-061\CAD\PUTAH - GRADING PLAN.dwg Updated By: TorSwift

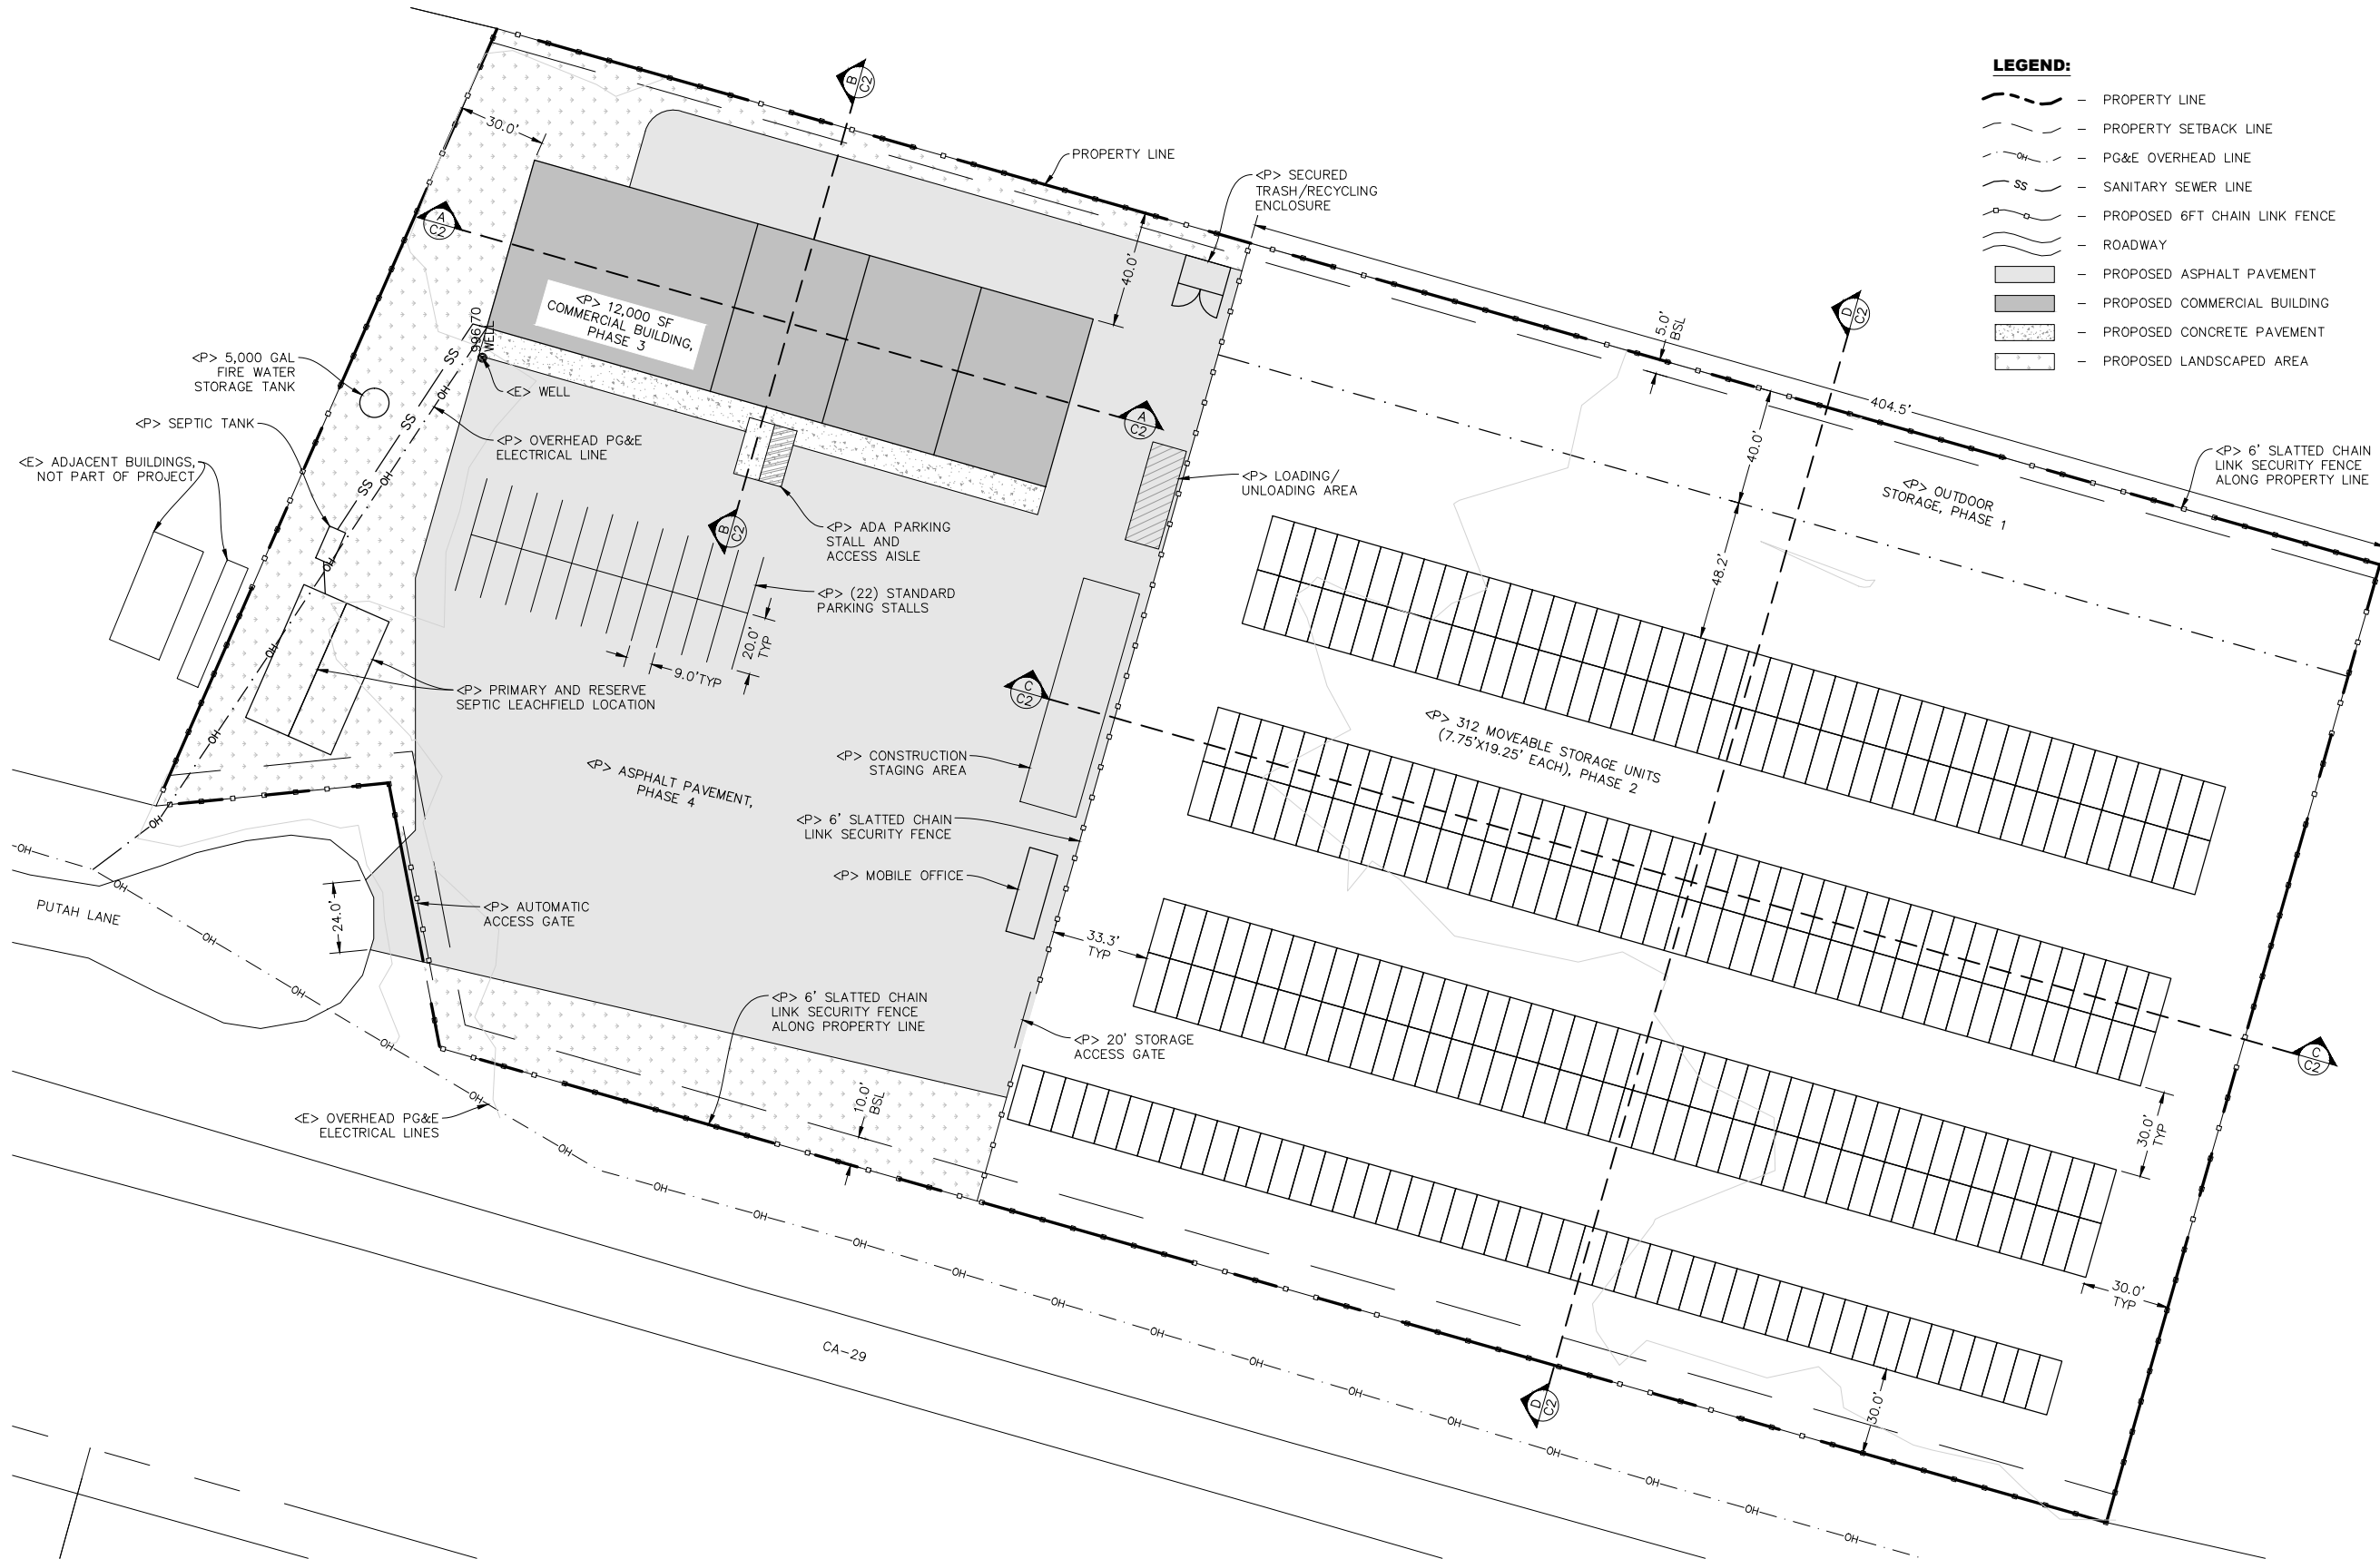

- LEGEND:**
- PROPERTY LINE
 - PROPERTY SETBACK LINE
 - PG&E OVERHEAD LINE
 - SS - SANITARY SEWER LINE
 - PROPOSED 6FT CHAIN LINK FENCE
 - ROADWAY
 - PROPOSED ASPHALT PAVEMENT
 - PROPOSED COMMERCIAL BUILDING
 - PROPOSED CONCRETE PAVEMENT
 - PROPOSED LANDSCAPED AREA

PROPOSED SITE PLAN

 22x34 SHEET: 1"=30'
11x17 SHEET: 1"=60'







NORTHPOINT
CONSULTING GROUP, INC.
1117 Samoa Blvd., Arcata, CA 95521

PUTAH STORAGE, LLC
18830 PUTAH LN., MIDDLETOWN, CA 95467 / APN:014-500-03
PROPOSED SITE PLAN

PROJ. MGR.: SN
DRAWN BY: TJS
DATE: 11/21/22
SCALE: AS SHOWN

SHEET
C2
22-061

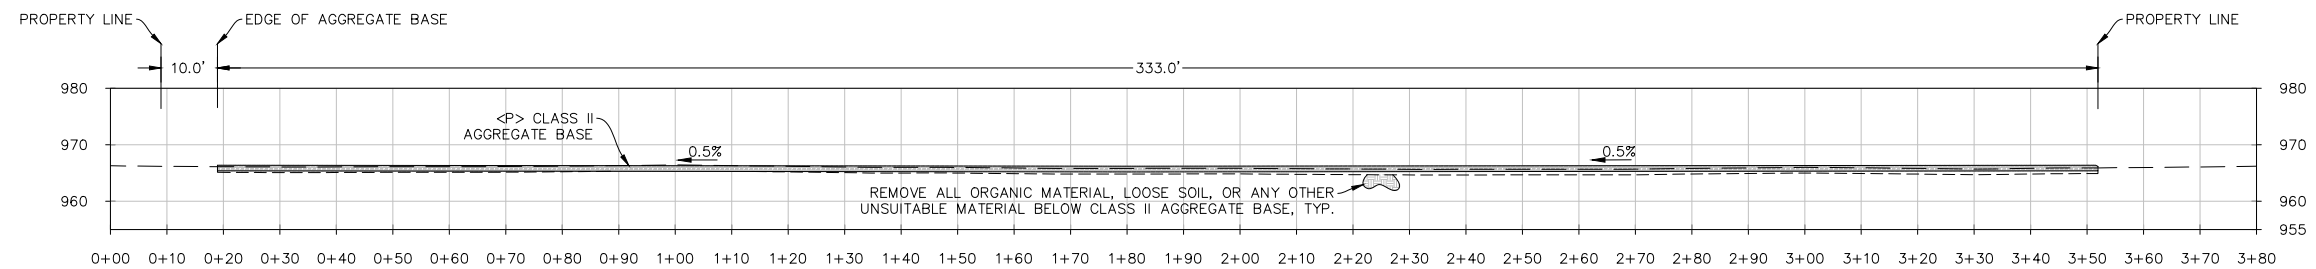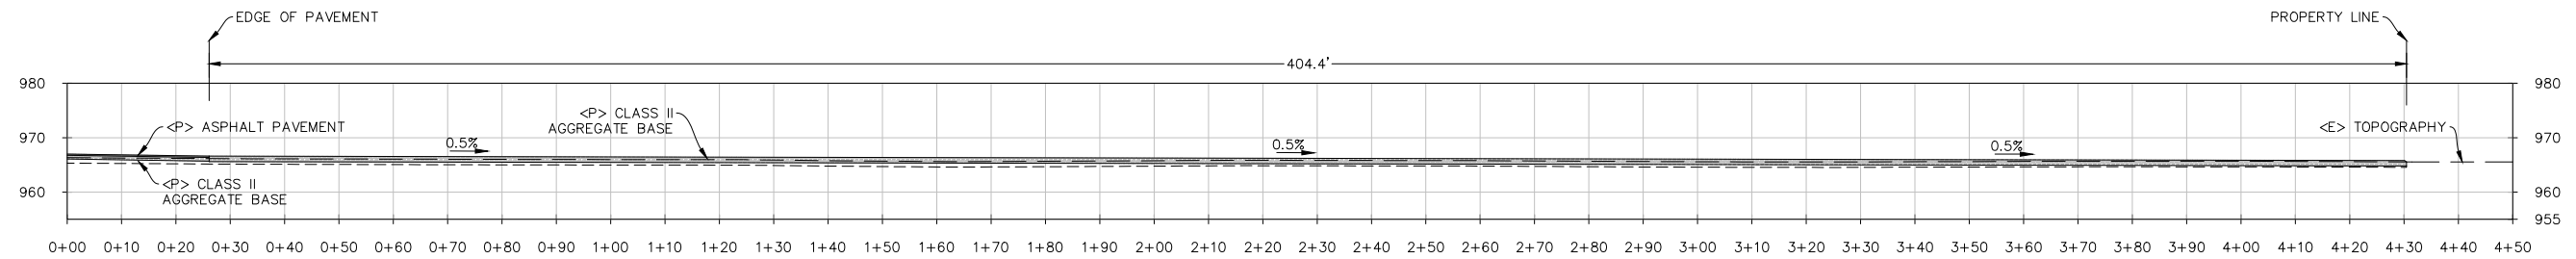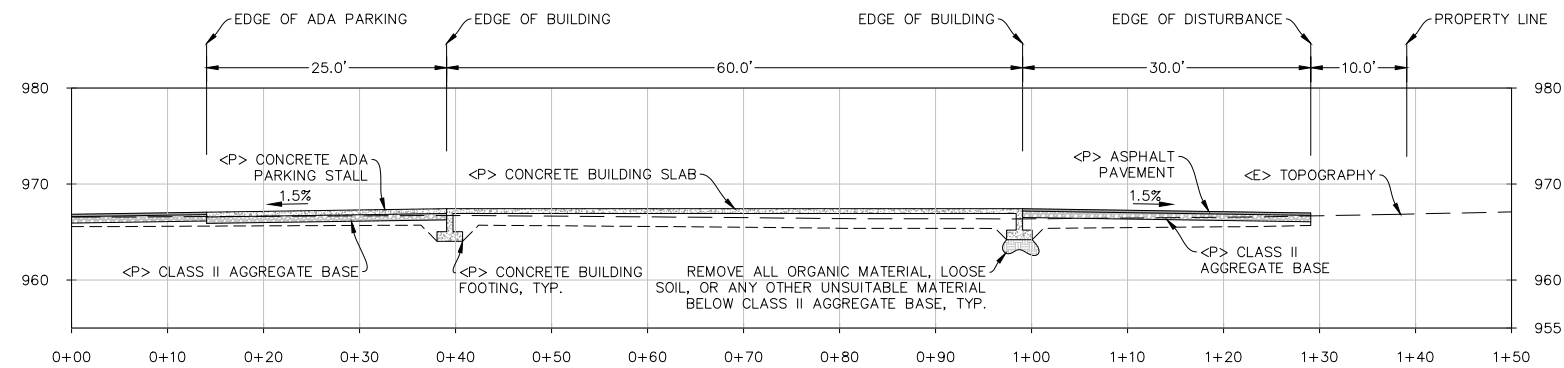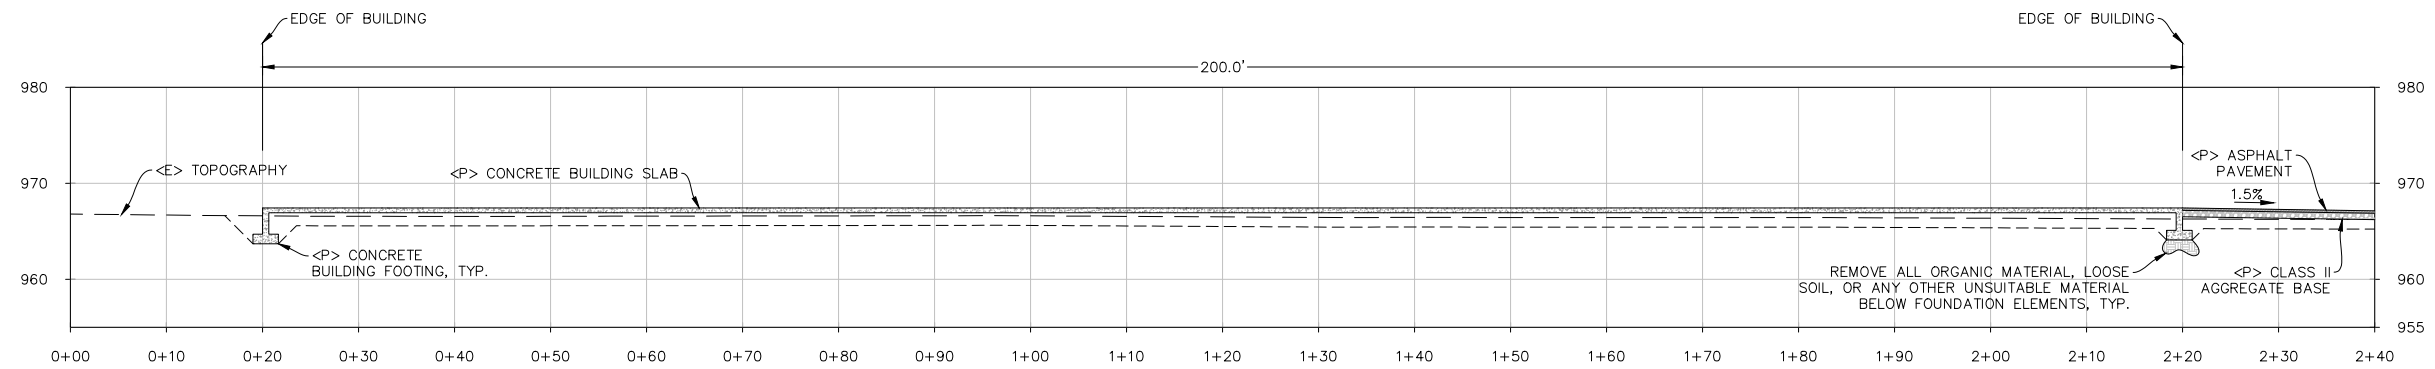

November 23, 2022 - 14:57 Dwg Name: P:\Putah Storage - 22-061\CAD\PUTAH - GRADING PLAN.dwg Updated By: TorySwift

[illegible]

NORTHPOINT
CONSULTING GROUP, INC.
1117 Samoa Blvd., Arcata, CA 95521




PUTAH STORAGE, LLC

18830 PUTAH LN., MIDDLETOWN, CA 95467 / APN:014-500-03

SECTION VIEWS

PROJ. MGR.:	<u>SN</u>
DRAWN BY:	<u>TJS</u>
DATE:	<u>11/21/22</u>
SCALE:	<u>AS SHOWN</u>

SHEET
C3
22-061

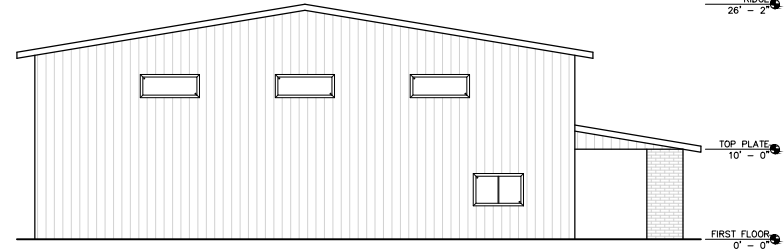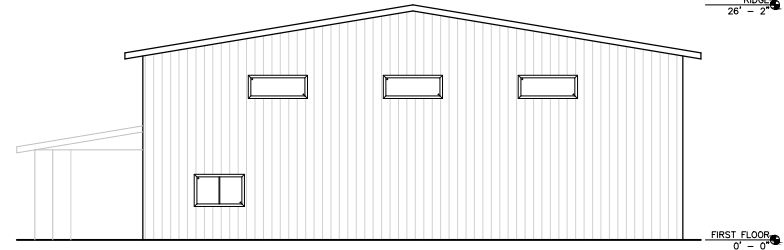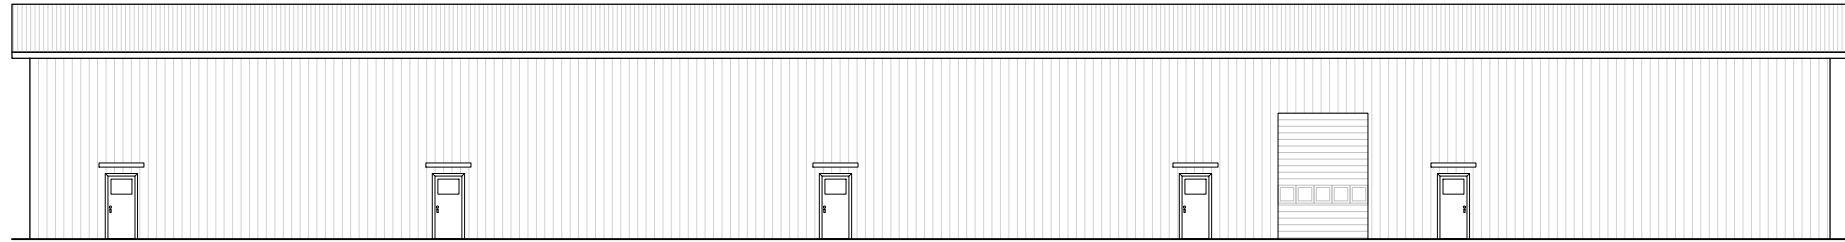
[illegible]

NORTHPOINT
CONSULTING GROUP, INC.
1117 Samoa Blvd., Arcata, CA 95521

PUTAH STORAGE, LLC
18930 PUTAH LN., MIDDLETOWN, CA 95467 / APN:014-500-03
ELEVATIONS

PROJ. MGR.: SN
DRAWN BY: CJG
DATE: 11/21/22
SCALE: AS SHOWN

SHEET
A1
22-061

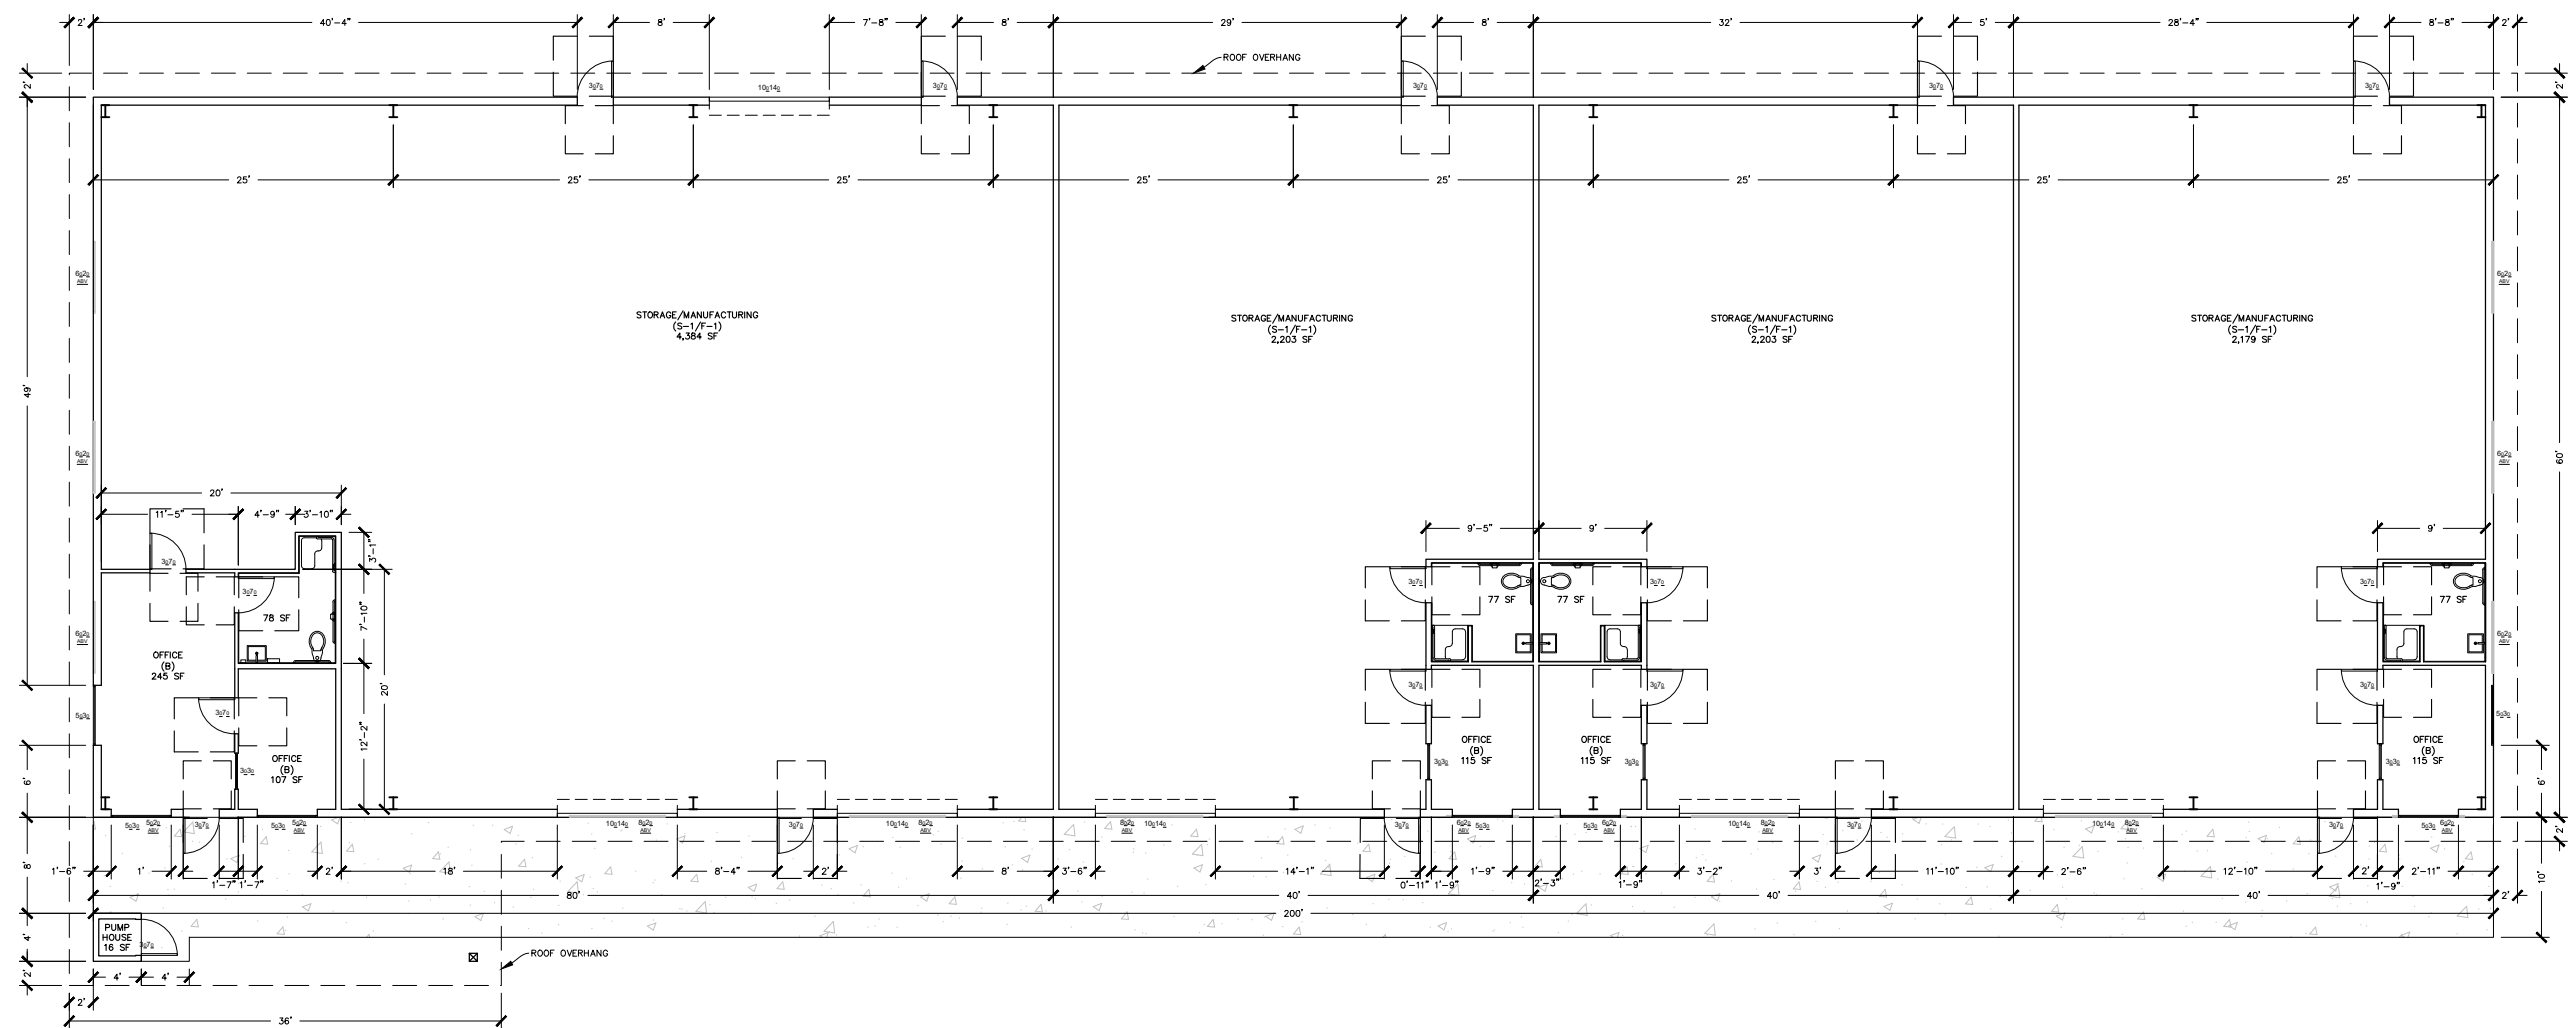

November 23, 2022 - 14:57 Dwg Name: P:\Putah Storage - 22-061\CAD\PUTAH - ARCH 22X34.dwg Updated By: TorySwift

FIRST FLOOR PLAN

[illegible]

NORTHPOINT
CONSULTING GROUP, INC.
1117 Samoa Blvd., Arcata, CA 95521

PUTAH STORAGE, LLC

18830 PUTAH LN., MIDDLETOWN, CA 95467 / APN:014-500-03

FLOOR PLAN

PROJ. MGR.: SN
DRAWN BY: CJG
DATE: 11/21/22
SCALE: AS SHOWN

SHEET

A2


22-061

SCALE: 1/16" = 1'-0"

November 21, 2022 - 16:28 Doc Name: P:\Putah Storage - 22-061\CAD\PUTAH - STORM WATER & LIGHTING.dwg Updated By: ToyShift

PUTAH STORAGE, LLC. PRELIMINARY LIGHTING PLAN

APN: 014-500-03

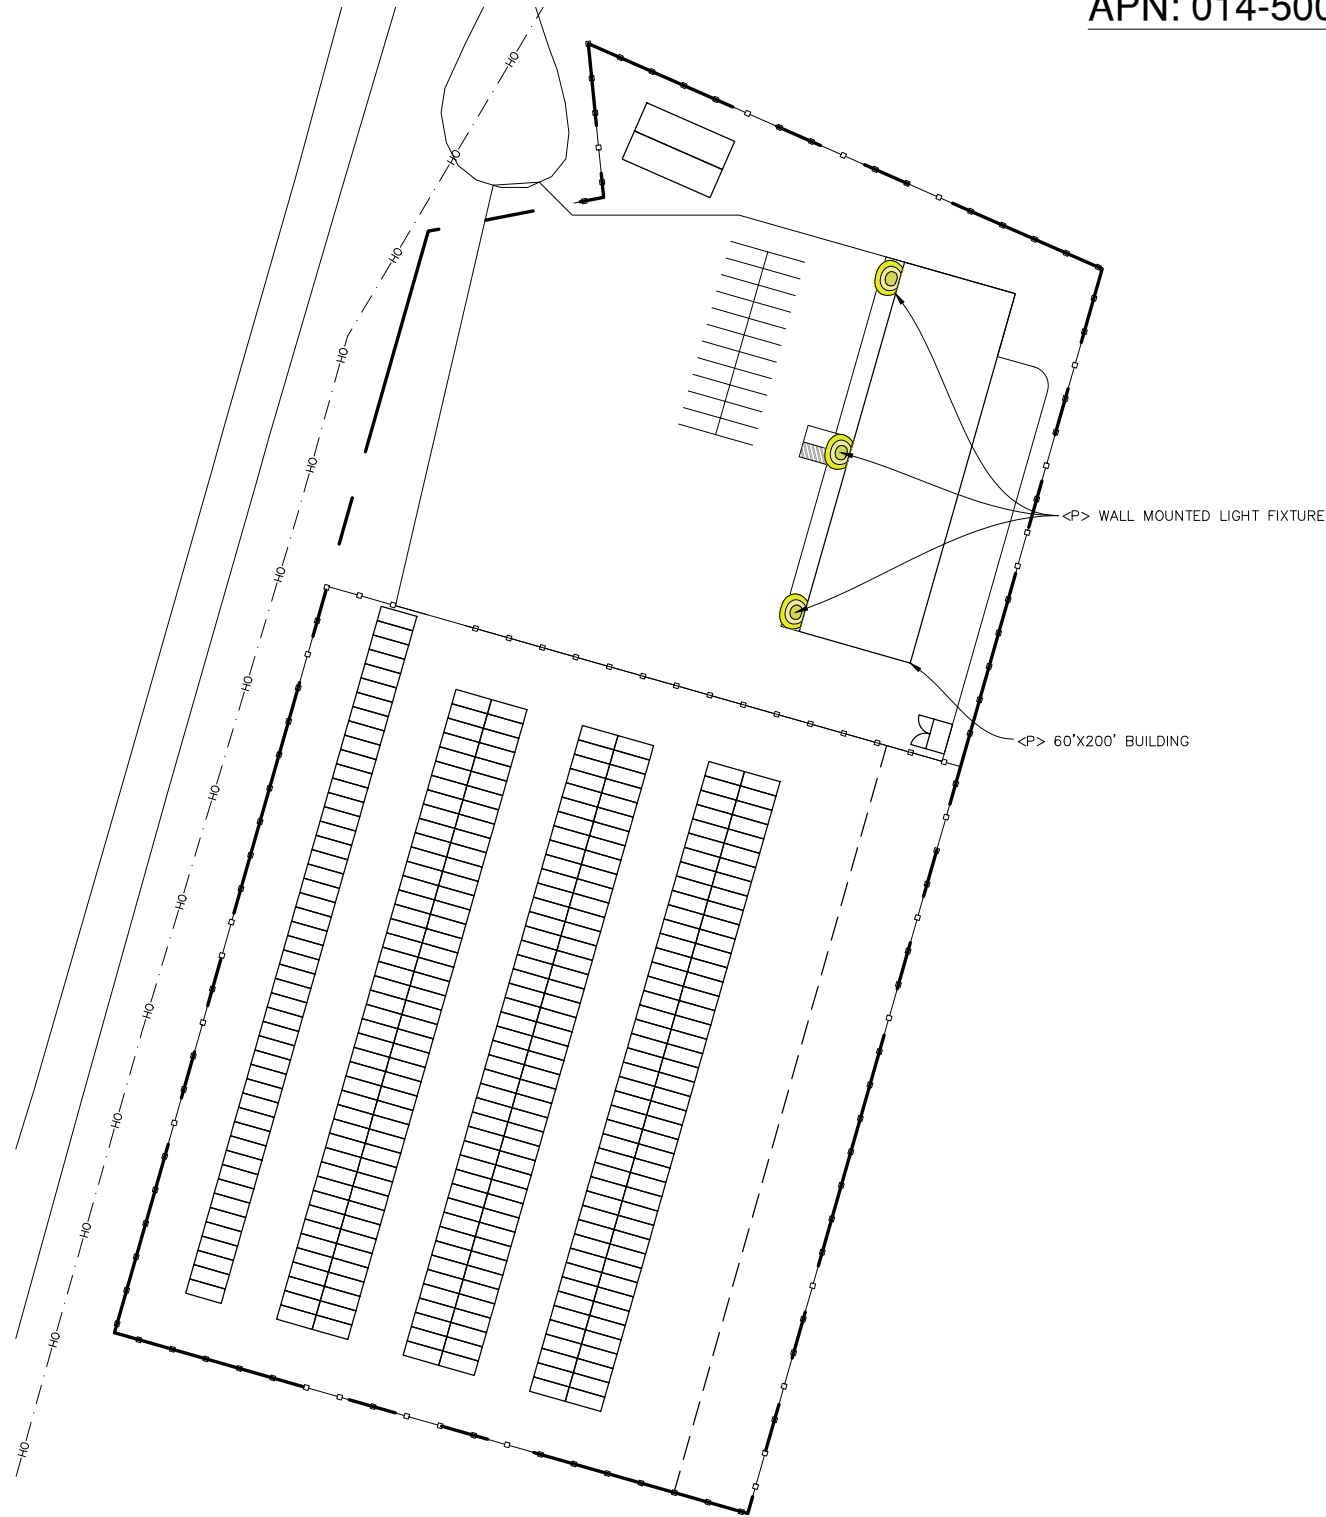


PROPOSED SITE PLAN

22x34 SHEET: 1"=50'
11x17 SHEET: 1"=100'
0 25 50 100



C-VT-A-SMWL/LGWL Series
LED Vapor Tights - Wall Mount - Small & Large
Replaces 100W/120W Incandescent

C-LITE
LED LIGHTING BY CREE

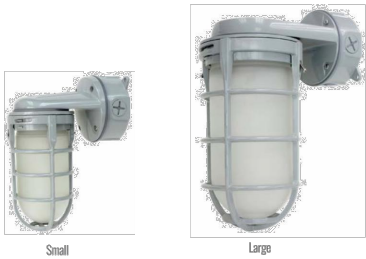

PRODUCT SPECIFICATIONS

OVERVIEW

- Initial Delivered Lumens: 900 (small), 1,200 (large)
- CRI: ≥ 70
- CCT: Neutral White 4000K
- Mounting: Wall
- Input Power: 14 Watts (small), 22 Watts (large)
- Dimmable: No
- Operating Range: -40°C (-40°F) - 50°C (122°F)
- Lifespan: Estimated 172,000 Hours (small), 118,000 Hours (large)
- Power Factor: > 0.9
- Total Harmonic Distortion: $< 20\%$
- Limited Warranty: 5 Years*
- Replaces 100W Incandescent (small), 120W Incandescent (large)

DURABLE	VERSATILE	RECOMMENDED USE	INPUT VOLTAGE
- Rugged time-tested design - Sturdy housing and frosted glass globe	- Protects against dust & moisture - Even clean light with several mounting options	- Cold Storage - Manufacturing - Bridges & Tunnels	120V Operation

ORDERING INFORMATION

Example: C-VT-A-SMWL-9L-40K-GR

C-VT-A			40K	GR
PRODUCT	STYLE	LUMEN PACKAGE	CCT	COLOR
C-VT-A	SMWL LED Vapor Tight Wall Mount Small	9L (small) 900 Lumens 14W	40K Neutral White (4000K)	GR Gray
	LGWL LED Vapor Tight Wall Mount Large	12L (large) 1,200 Lumens 22W		


CERTIFICATIONS:

US: c-lite.com T (800) 236-6800 F (262) 504-5415 Canada: www.cree.com/canada T (800) 473-1234 F (800) 880-7507
Rev. Date V3 10/25/2018 For informational purposes only. Content is subject to change. *See lighting.cree.com/warranty for details



WALL MOUNTED LIGHT SPECIFICATIONS

N.T.S.

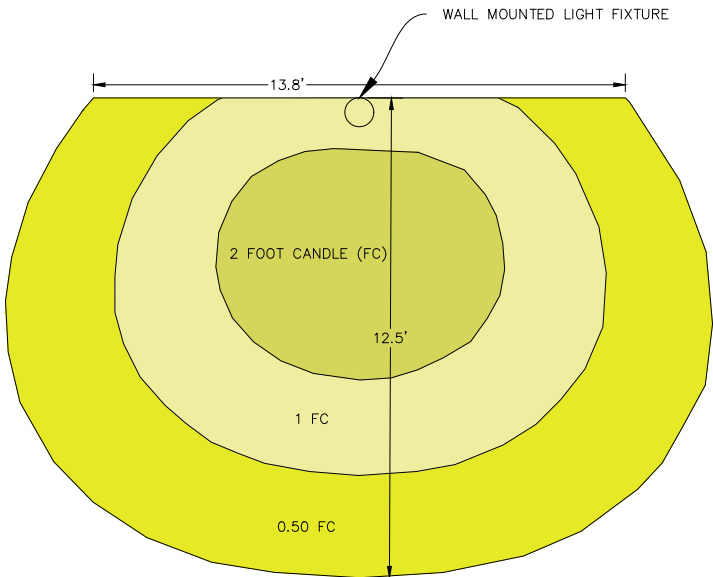

SITE LIGHT PHOTOMETRIC

PLAN VIEW
N.T.S.

NOTE:

LIGHT PHOTOMETRICS
OBTAINED FROM LIGHTING
ANALYSIS, INC.

PUTAH STORAGE, LLC

18830 PUTAH LN., MIDDLETOWN, CA 95467 / APN:014-500-03

PROPOSED LIGHTING SITE PLAN

PROJ. MGR.: SN
DRAWN BY: DR
DATE: 11/21/22
SCALE: AS SHOWN

SHEET

LP1

22-061